
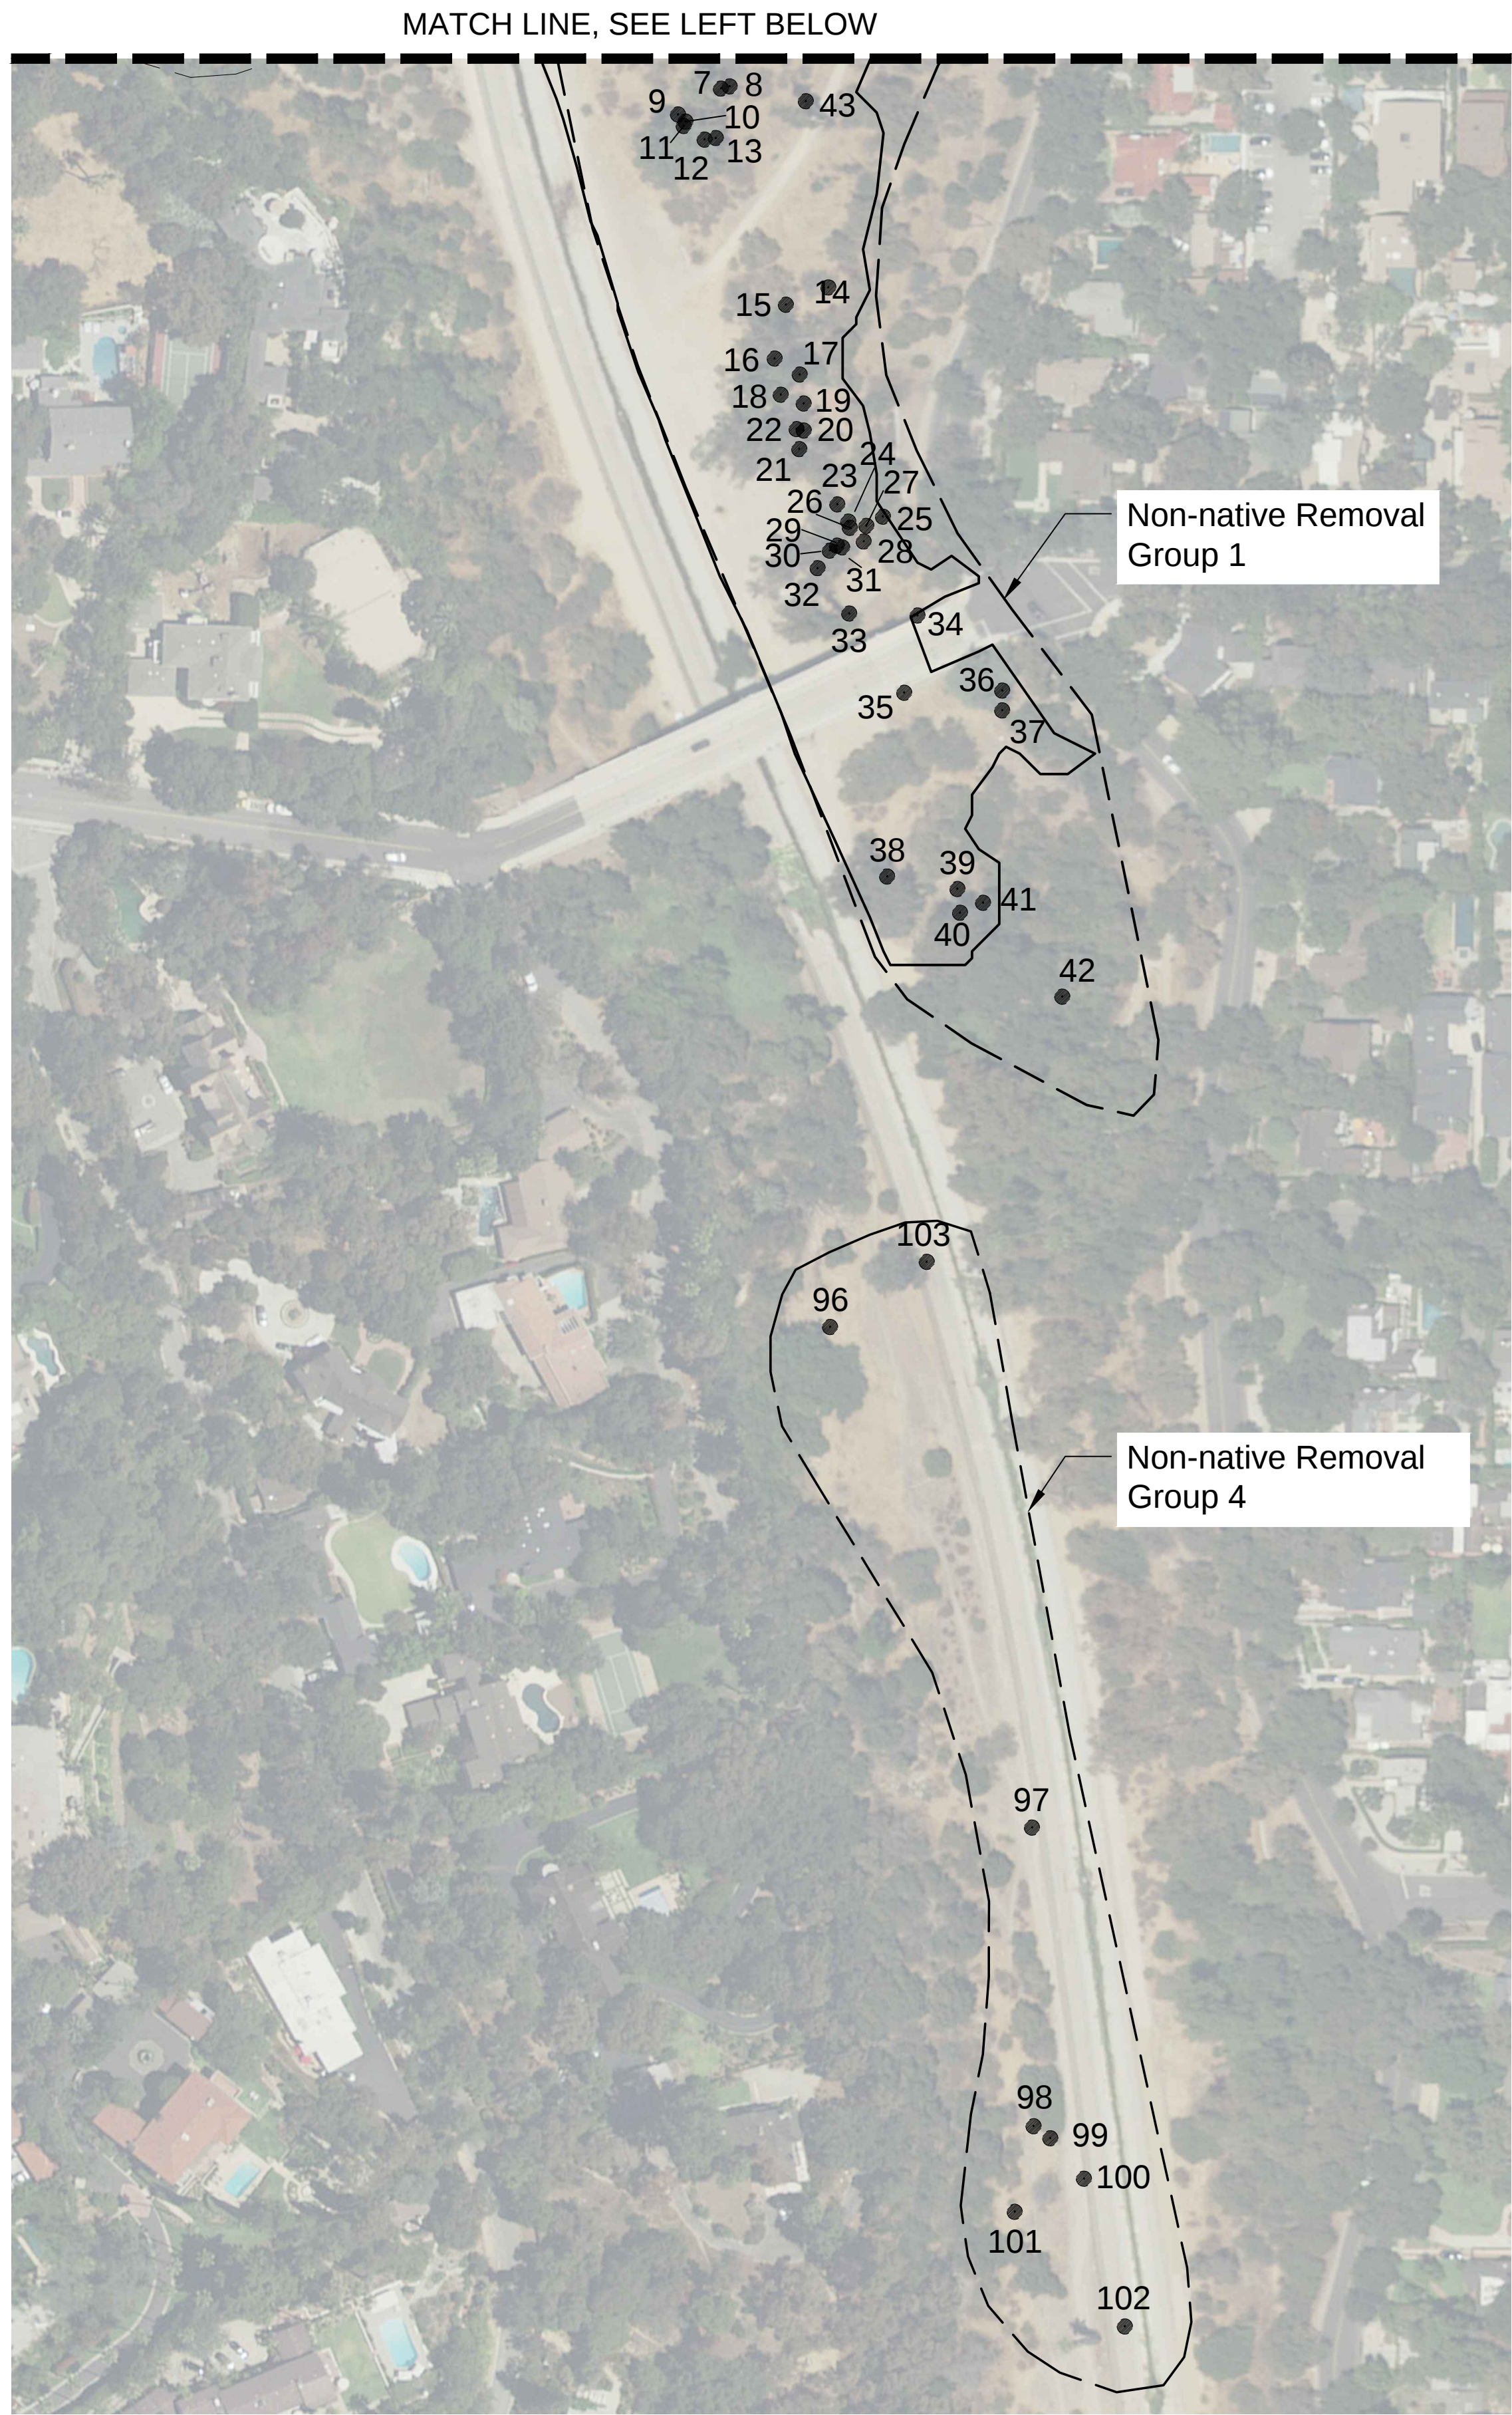


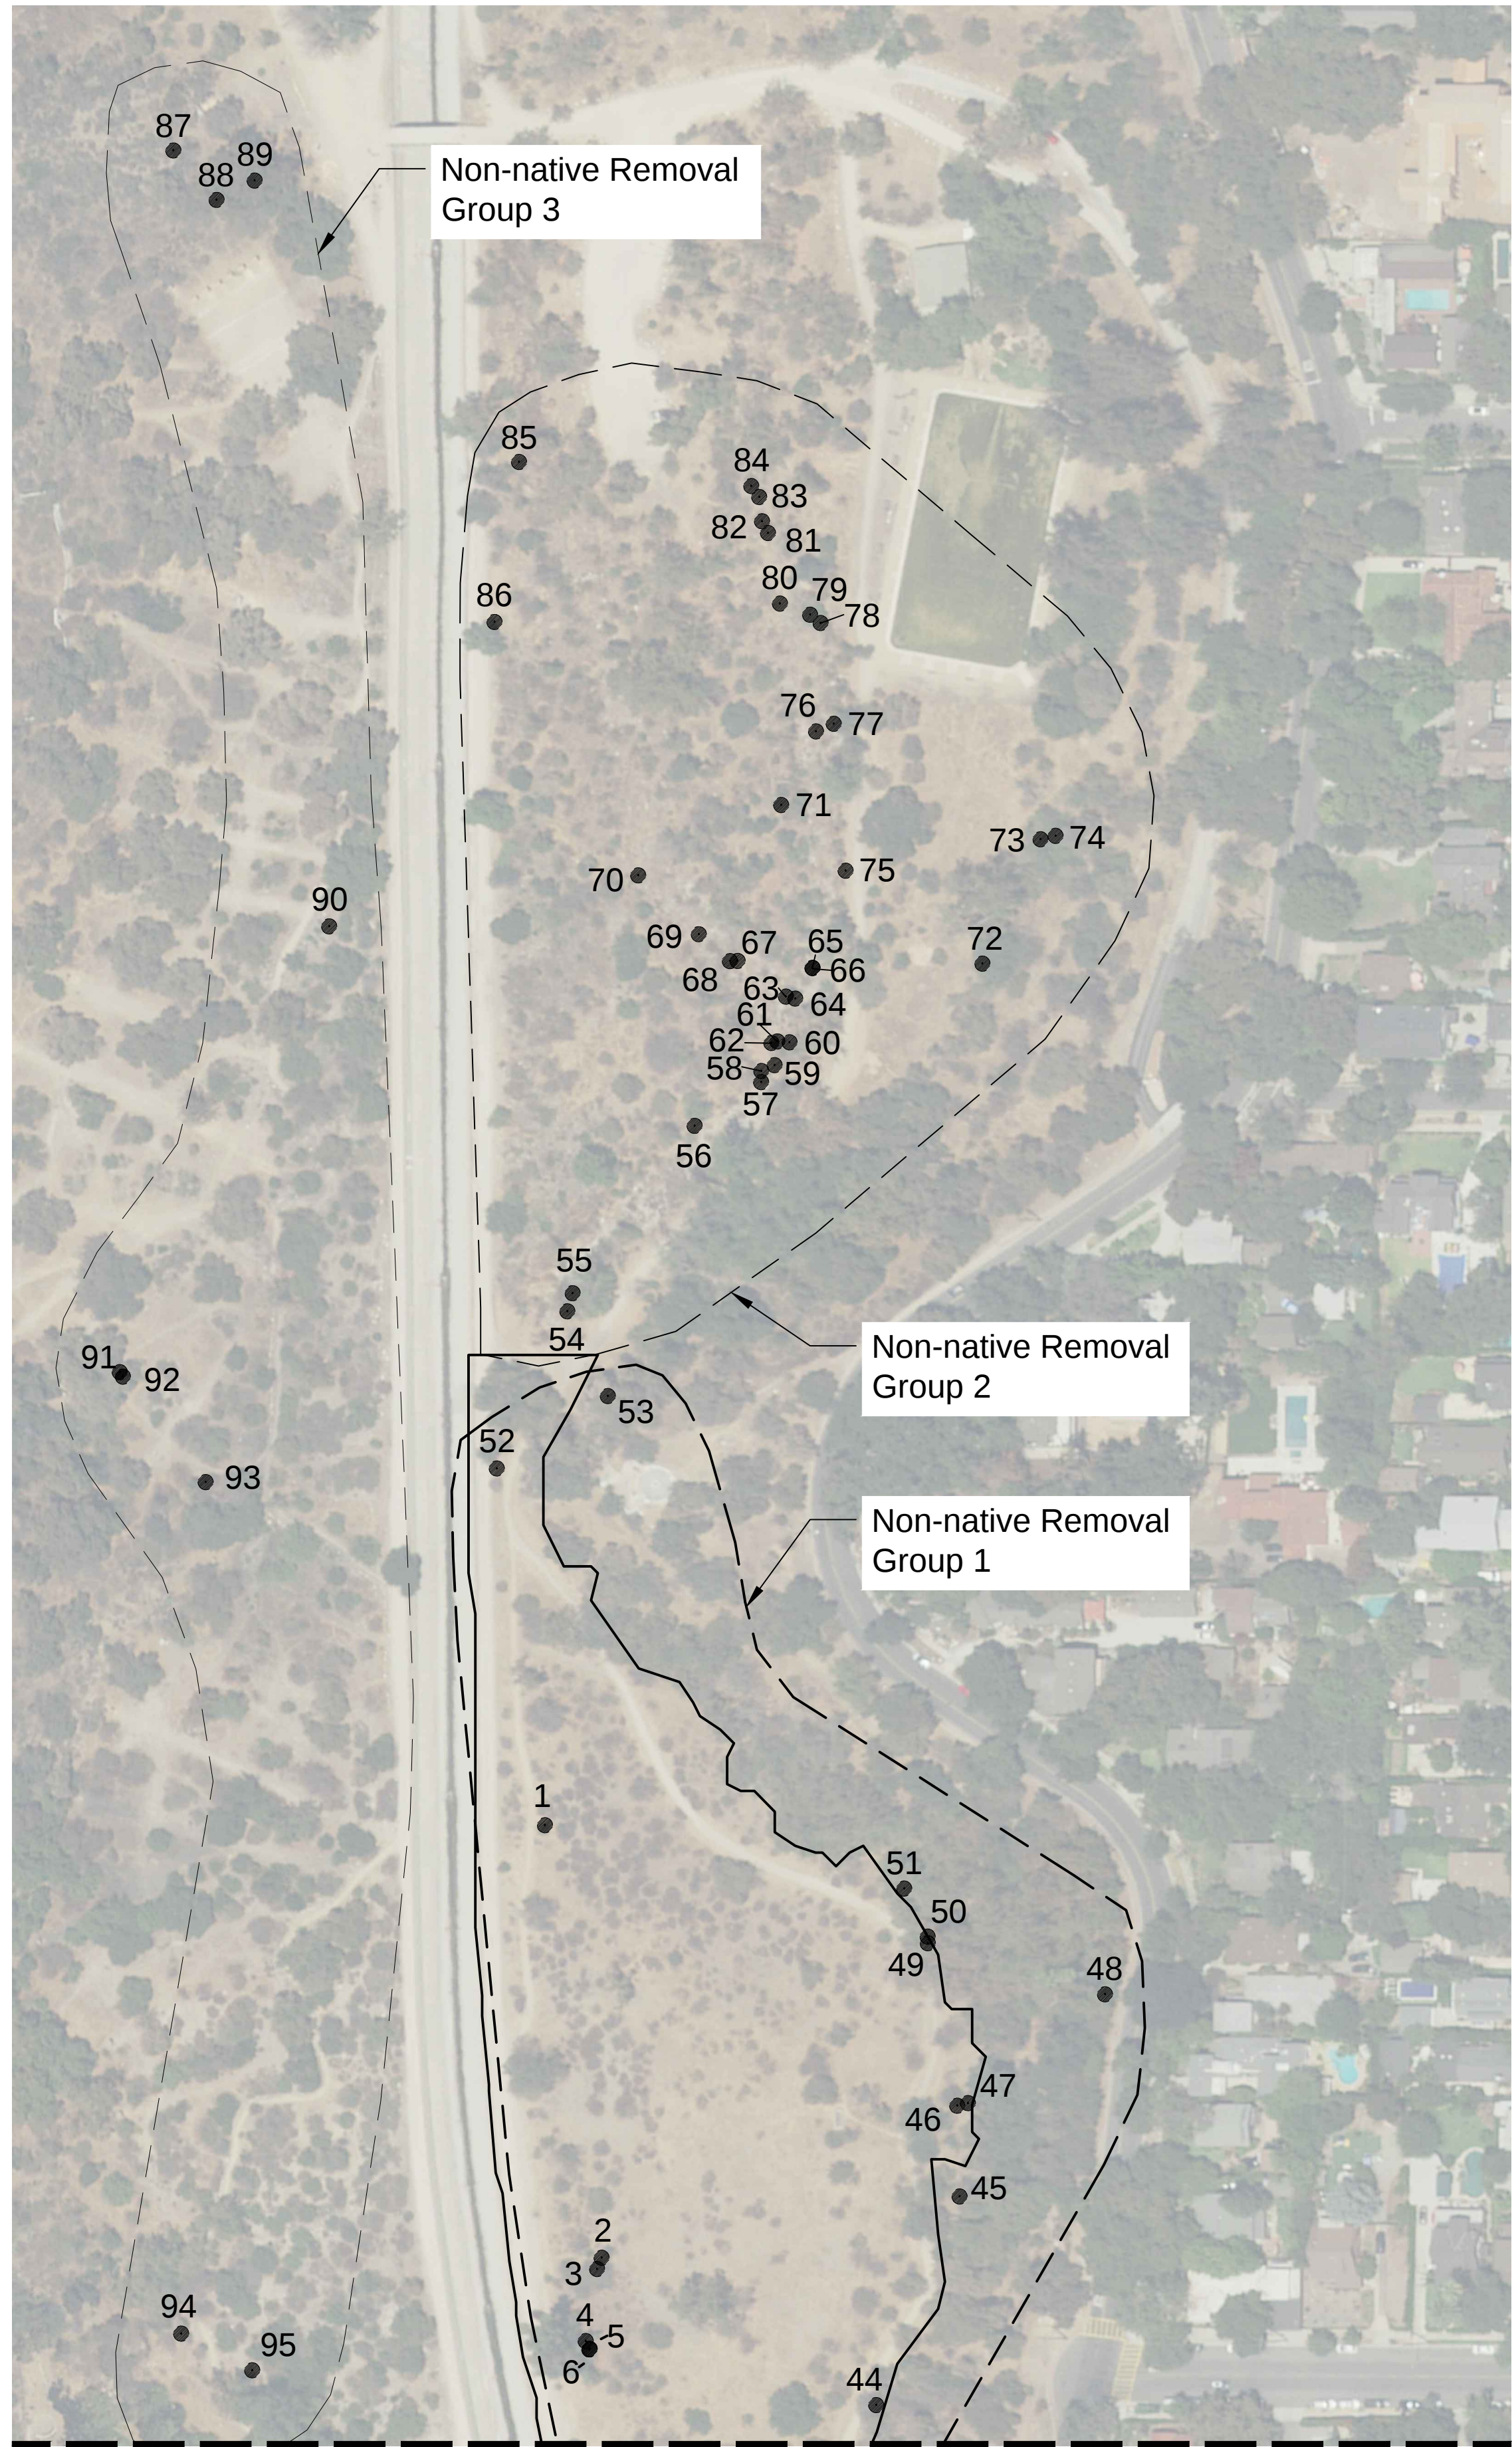


LEGEND - NON-NATIVE TREE/ PLANT REMOVAL

78	Brazilian Peppertree (<i>Schinus terebinthifolius</i>)
4-13,43	Canary Island Pine (<i>Pinus canariensis</i>)
76	Carrotwood (<i>Cupaniopsis ananardioides</i>)
56,59,72-74,96	Chinese Elm (<i>Ulmus parvifolia</i>)
53	Chinese Flame Tree (<i>Koelreuteria bipinnata</i>)
58,62	Common Fig (<i>Ficus carica</i>)
63	Crimson Bottlebrush (<i>Callistemon citrinus</i>)
97	Cyclops Acacia (<i>Acacia cyclops</i>)
64,67,70,71,77,81,83	Date Palm (<i>Phoenix sp.</i>)
36,37	Deodar Cedar (<i>Cedrus deodara</i>)
42,44,51	European Hackberry (<i>Celtis australis</i>)
98,99,101	Golden Wattle (<i>Acacia longifolia</i>)
48,66,69,75,82,85,102	Mexican Fan Palm (<i>Washingtonia robusta</i>)
79	Mulberry (<i>Morus alba</i>)
2,3,15,25,45-47,49,50,52,93,94	Olive (<i>Olea europaea</i>)
80,84	Pampas Grass (<i>Cortaderia selloana</i>)
16-24,26-33,38-41,87-89,95,103	Red Gum (<i>Eucalyptus camaldulensis</i>)
54,55,57,60,61,65,68	Shamel Ash (<i>Fraxinus uhdei</i>)
100	Snag
1,14,86,90-92	Tree of Heaven (<i>Ailanthus altissima</i>)
34,35	Tree Tobacco (<i>Nicotiana glauca</i>)

 Project Boundary

NOTE:
REFER TO SPECIFICATIONS II.8.02 & II.8.03, AND TABLE #2 FOR ADDITIONAL INFORMATION.


NON-NATIVE TREE/PLANT REMOVAL PLAN

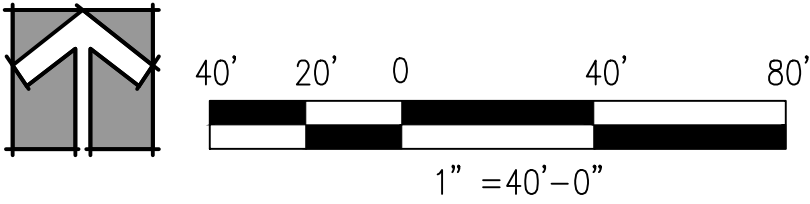

CORNERSTONE STUDIOS, INC.
951 E Santa Ana Blvd. 714. 973. 2200 Voice
Santa Ana, CA 92701 714. 973. 0203 Fax
LANDSCAPE ARCHITECTURE • URBAN DESIGN • PLANNING • RESOURCE ANALYSIS



DESIGNED BY:	REVISIONS						CITY OF PASADENA - DEPARTMENT OF PUBLIC WORKS		
DRAWN BY:	MARK	DATE	DESCRIPTION	BY	CHKD.	APPROVED	PROJECT	LOWER ARROYO SECO / VAN DE KAMP BRIDGE HABITAT RESTORATION PROJECT	SHEET 2 OF 8
CHECKED BY:							LIMITS	-	DWG. NO. #
			AS BUILT				SCALE	1"=40'	ACCOUNT NO. -

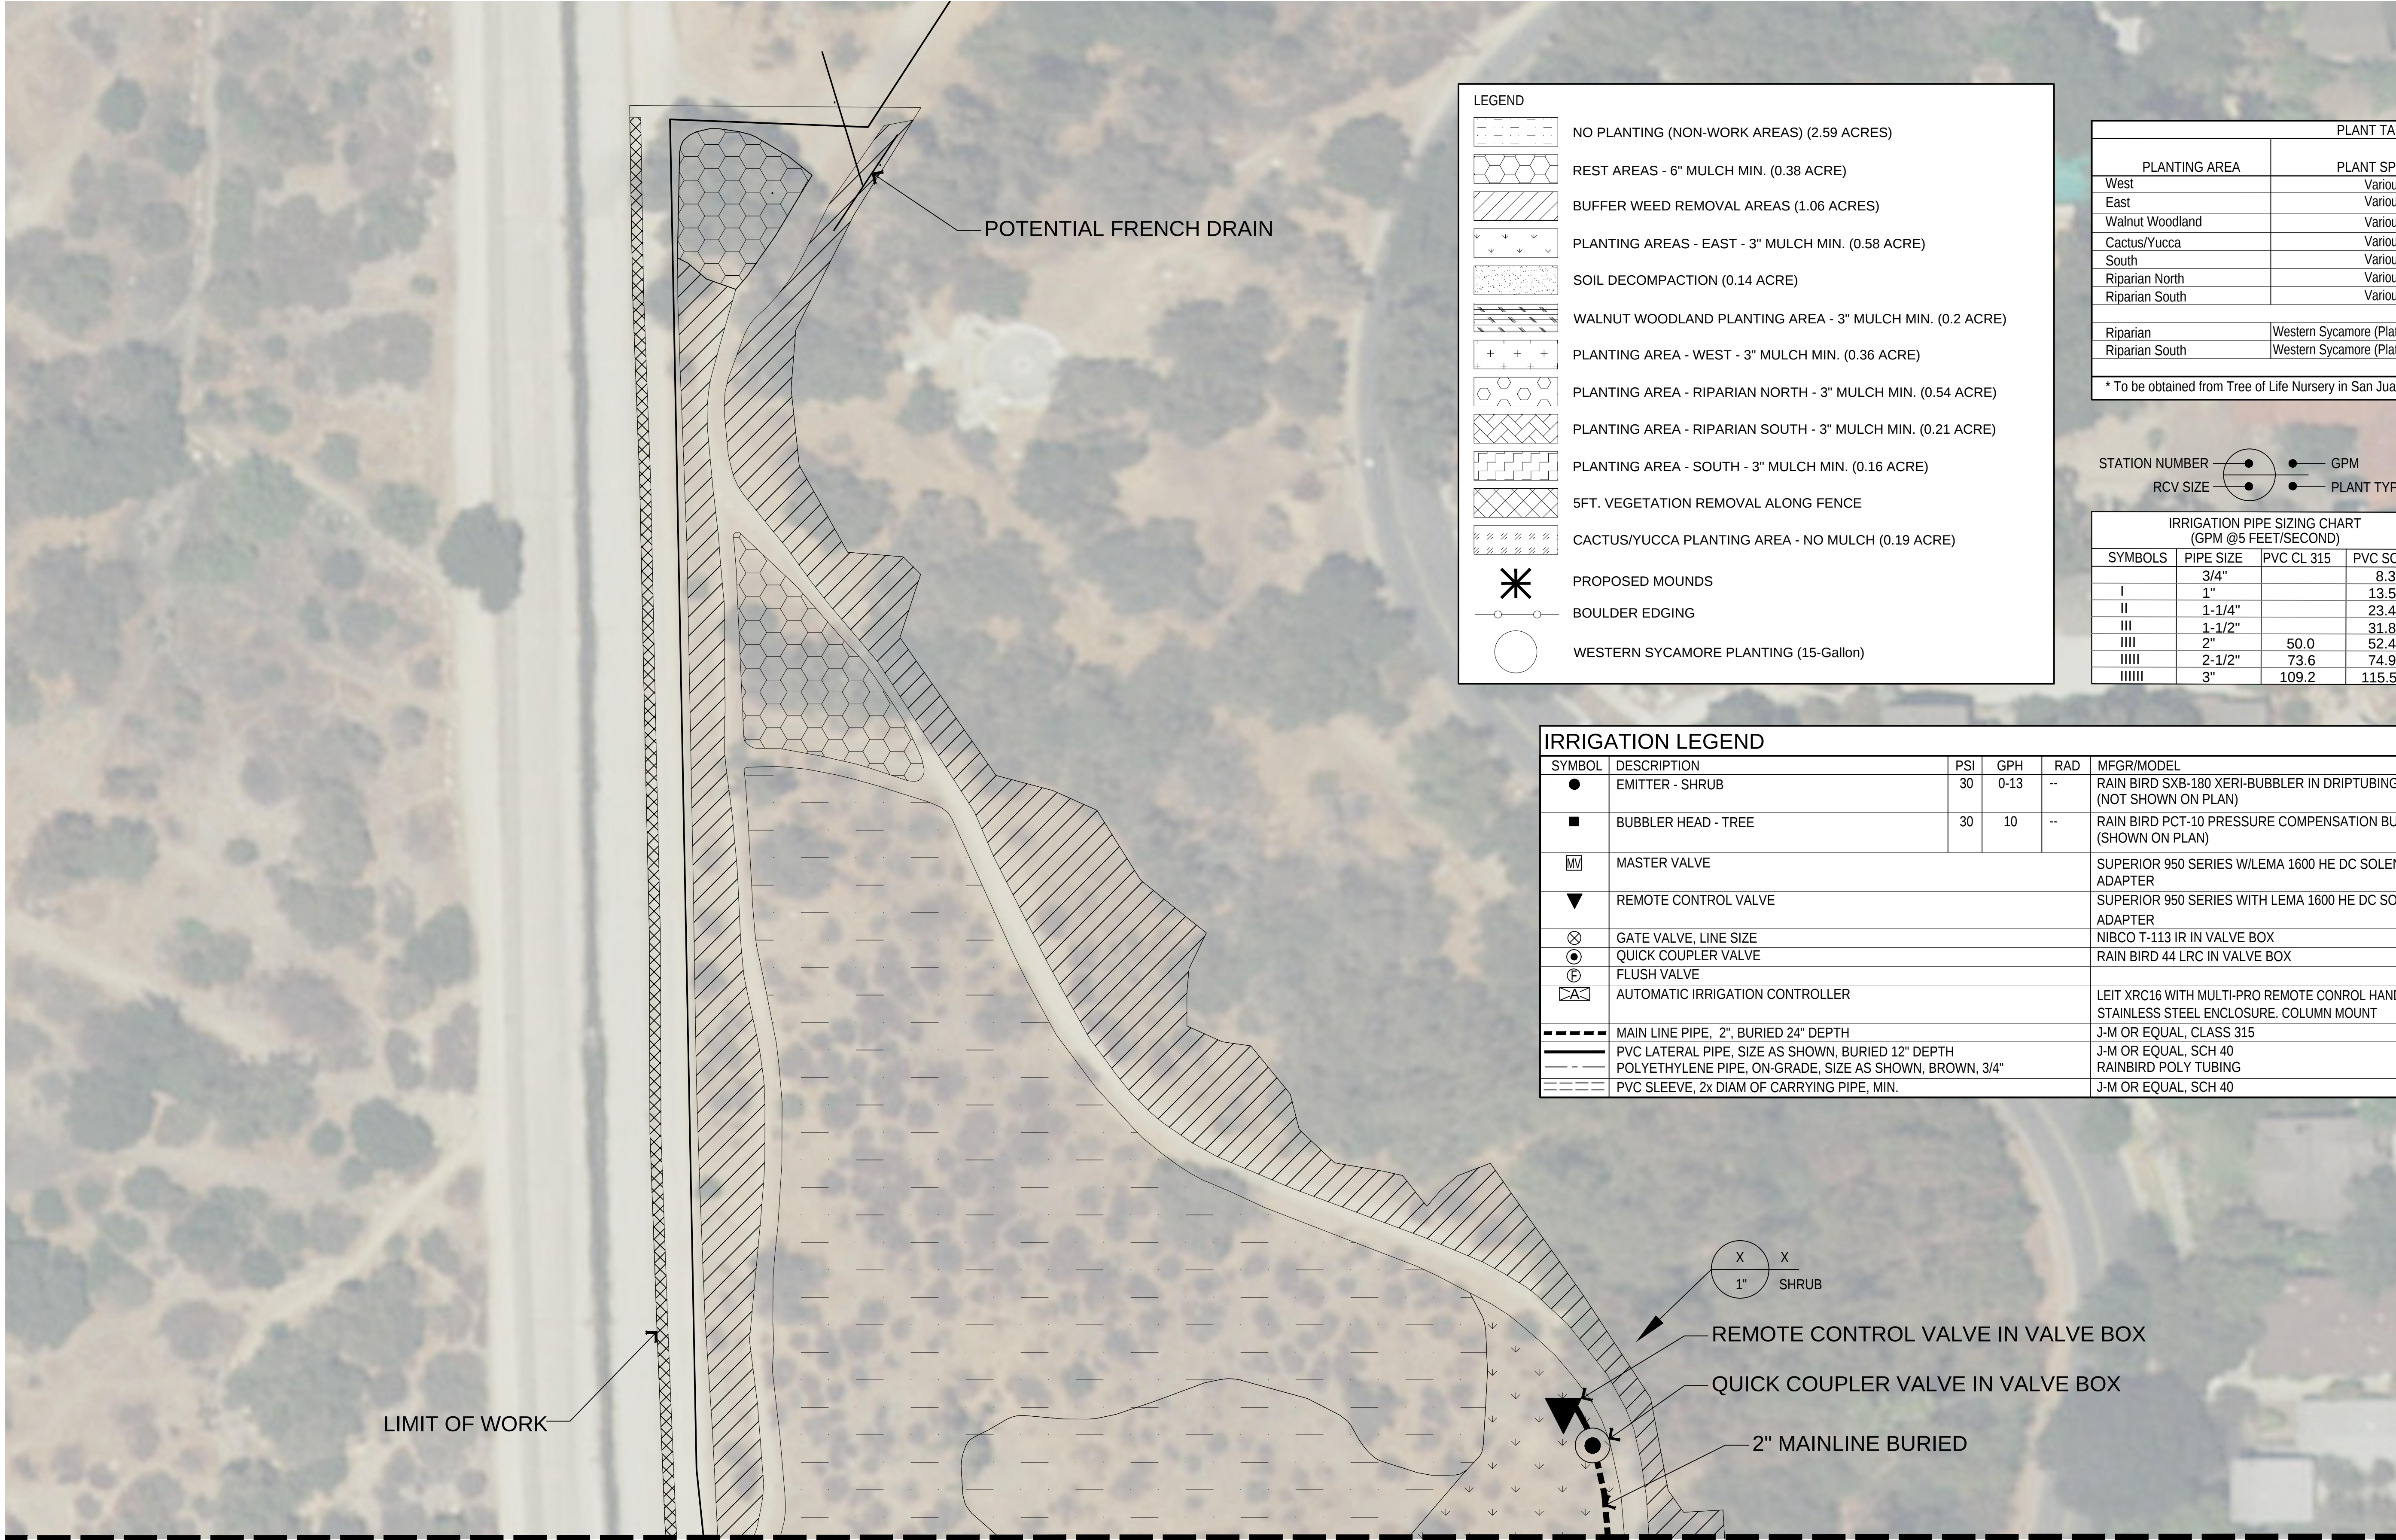

LEGEND

NO PLANTING (NON-WORK AREAS) (2.59 ACRES)

REST AREAS - 6" MULCH MIN. (0.38 ACRE)

BUFFER WEED REMOVAL AREAS (1.06 ACRES)

PLANTING AREAS - EAST - 3" MULCH MIN. (0.58 ACRE)

SOIL DECOMPACTION (0.14 ACRE)

WALNUT WOODLAND PLANTING AREA - 3" MULCH MIN. (0.2 ACRE)

PLANTING AREA - WEST - 3" MULCH MIN. (0.36 ACRE)

PLANTING AREA - RIPARIAN NORTH - 3" MULCH MIN. (0.54 ACRE)

PLANTING AREA - RIPARIAN SOUTH - 3" MULCH MIN. (0.21 ACRE)

PLANTING AREA - SOUTH - 3" MULCH MIN. (0.16 ACRE)

5FT. VEGETATION REMOVAL ALONG FENCE

CACTUS/YUCCA PLANTING AREA - NO MULCH (0.19 ACRE)

PROPOSED MOUNDS

BOULDER EDGING


WESTERN SYCAMORE PLANTING (15-Gallon)

PLANT TABLE			
PLANTING AREA	PLANT SPECIES	SIZE	QUANTITY
West	Various	1-Gallon	226
East	Various	1-Gallon	550
Walnut Woodland	Various	1-Gallon	220
Cactus/Yucca	Various	1-Gallon	205
South	Various	1-Gallon	131
Riparian North	Various	1-Gallon	587
Riparian South	Various	1-Gallon	81
TOTAL			2,000
Riparian	Western Sycamore (Platanus racemosa)*	15-Gallon	15
Riparian South	Western Sycamore (Platanus racemosa)*	15-Gallon	2
TOTAL			17
* To be obtained from Tree of Life Nursery in San Juan Capistrano, CA			



IRRIGATION PIPE SIZING CHART (GPM @5 FEET/SECOND)			
SYMBOLS	PIPE SIZE	PVC CL 315	PVC SCH 40
I	3/4"		8.3
II	1"		13.5
III	1-1/4"		23.4
IIII	1-1/2"		31.8
IIIII	2"	50.0	52.4
IIIIII	2-1/2"	73.6	74.9
IIIIIII	3"	109.2	115.5

IRRIGATION LEGEND						
SYMBOL	DESCRIPTION	PSI	GPH	RAD	MFGR/MODEL	DETAILS
●	EMITTER - SHRUB	30	0-13	--	RAIN BIRD SXB-180 XERI-BUBBLER IN DRIPTUBING (NOT SHOWN ON PLAN)	SHEET 6, DETAIL K
■	BUBBLER HEAD - TREE	30	10	--	RAIN BIRD PCT-10 PRESSURE COMPENSATION BUBBLER ON RISER (SHOWN ON PLAN)	SHEET 7, DETAIL A
MM	MASTER VALVE				SUPERIOR 950 SERIES W/LEMA 1600 HE DC SOLENOID ACTUATOR & ADAPTER	SHEET 6, DETAIL B
▼	REMOTE CONTROL VALVE				SUPERIOR 950 SERIES WITH LEMA 1600 HE DC SOLENOID ACTUATOR & ADAPTER	SHEET 6, DETAIL J
⊗	GATE VALVE, LINE SIZE				NIBCO T-113 IR IN VALVE BOX	SHEET 6, DETAIL E
⊙	QUICK COUPLER VALVE				RAIN BIRD 44 LRC IN VALVE BOX	SHEET 6, DETAIL G
⊕	FLUSH VALVE					SHEET 6, DETAIL D
Ⓜ	AUTOMATIC IRRIGATION CONTROLLER				LEIT XRC16 WITH MULTI-PRO REMOTE CONTROL HANDSET STAINLESS STEEL ENCLOSURE. COLUMN MOUNT	SHEET 6, DETAIL I
---	MAIN LINE PIPE, 2", BURIED 24" DEPTH				J-M OR EQUAL, CLASS 315	SHEET 6, DETAIL A
---	PVC LATERAL PIPE, SIZE AS SHOWN, BURIED 12" DEPTH				J-M OR EQUAL, SCH 40	
---	POLYETHYLENE PIPE, ON-GRADE, SIZE AS SHOWN, BROWN, 3/4"				RAINBIRD POLY TUBING	SHEET 6, DETAIL A
---	PVC SLEEVE, 2x DIAM OF CARRYING PIPE, MIN.				J-M OR EQUAL, SCH 40	SHEET 6, DETAIL A

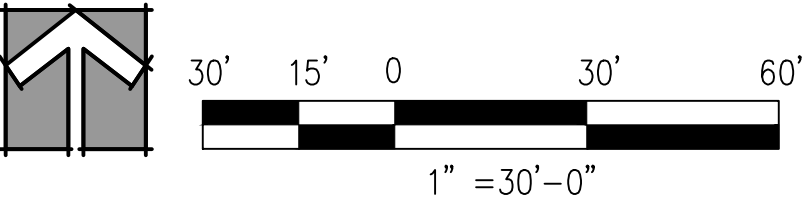


CORNERSTONE STUDIOS, INC.
951 E Santa Ana Blvd. Santa Ana, CA 92701
714. 973. 2200 Voice 714. 973. 0203 Fax
LANDSCAPE ARCHITECTURE • URBAN DESIGN • PLANNING • RESOURCE ANALYSIS



DESIGNED BY:		REVISIONS					CITY OF PASADENA - DEPARTMENT OF PUBLIC WORKS		
DRAWN BY:		MARK	DATE	DESCRIPTION	BY	CHKD.	APPROVED	PROJECT	LOWER ARROYO SECO / VAN DE KAMP BRIDGE HABITAT RESTORATION PROJECT
CHECKED BY:								LIMITS	-
				AS BUILT				SCALE	1"=30'
								ACCOUNT NO.	-
								DWG. NO.	#
								SHEET	3 OF 8

IRRIGATION/ PLANTING PLAN

MATCH LINE, SEE SHEET-3

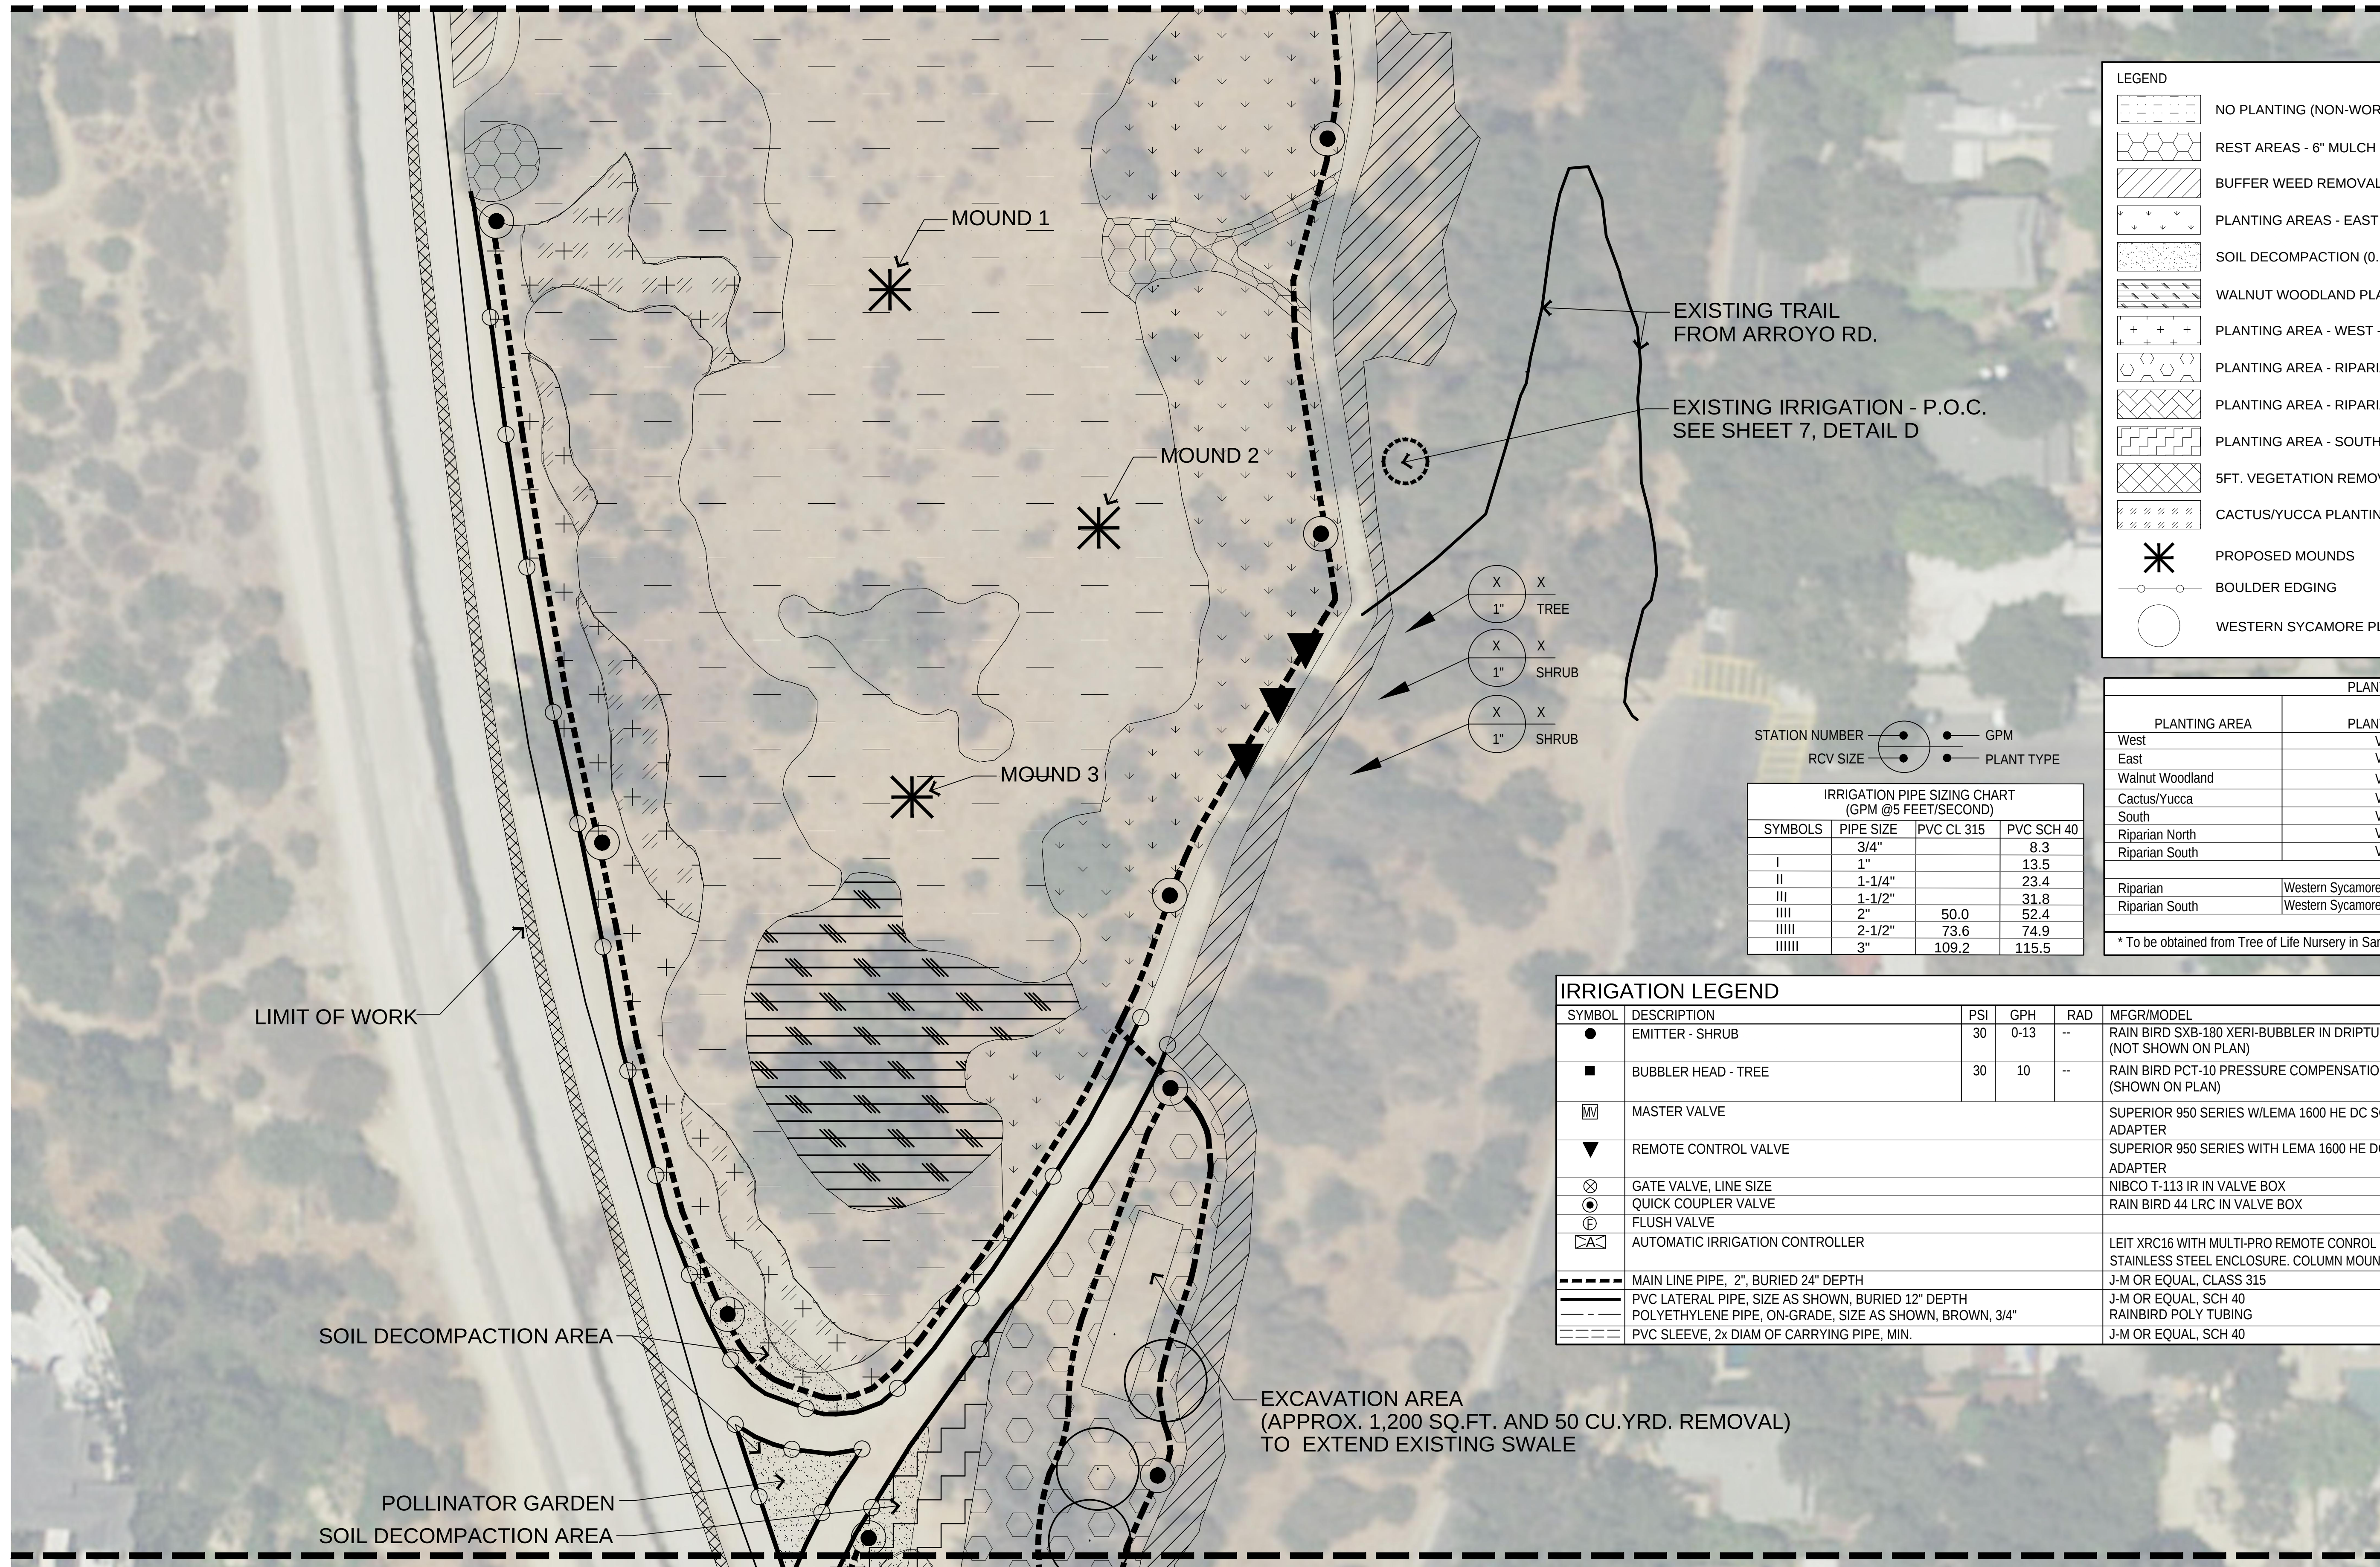

LEGEND	
	NO PLANTING (NON-WORK AREAS) (2.59 ACRES)
	REST AREAS - 6" MULCH MIN. (0.38 ACRE)
	BUFFER WEED REMOVAL AREAS (1.06 ACRES)
	PLANTING AREAS - EAST - 3" MULCH MIN. (0.58 ACRE)
	SOIL DECOMPACTION (0.14 ACRE)
	WALNUT WOODLAND PLANTING AREA - 3" MULCH MIN. (0.2 ACRE)
	PLANTING AREA - WEST - 3" MULCH MIN. (0.36 ACRE)
	PLANTING AREA - RIPARIAN NORTH - 3" MULCH MIN. (0.54 ACRE)
	PLANTING AREA - RIPARIAN SOUTH - 3" MULCH MIN. (0.21 ACRE)
	PLANTING AREA - SOUTH - 3" MULCH MIN. (0.16 ACRE)
	5FT. VEGETATION REMOVAL ALONG FENCE
	CACTUS/YUCCA PLANTING AREA - NO MULCH (0.19 ACRE)
	PROPOSED MOUNDS
	BOULDER EDGING
	WESTERN SYCAMORE PLANTING (15-Gallon)

STATION NUMBER
RCV SIZE

● GPM
● PLANT TYPE

IRRIGATION PIPE SIZING CHART (GPM @5 FEET/SECOND)			
SYMBOLS	PIPE SIZE	PVC CL 315	PVC SCH 40
I	3/4"		8.3
II	1"		13.5
III	1-1/4"		23.4
IIII	1-1/2"		31.8
IIIII	2"	50.0	52.4
IIIIII	2-1/2"	73.6	74.9
IIIIIII	3"	109.2	115.5

PLANT TABLE			
PLANTING AREA	PLANT SPECIES	SIZE	QUANTITY
West	Various	1-Gallon	226
East	Various	1-Gallon	550
Walnut Woodland	Various	1-Gallon	220
Cactus/Yucca	Various	1-Gallon	205
South	Various	1-Gallon	131
Riparian North	Various	1-Gallon	587
Riparian South	Various	1-Gallon	81
TOTAL			2,000
Riparian	Western Sycamore (Platanus racemosa)*	15-Gallon	15
Riparian South	Western Sycamore (Platanus racemosa)*	15-Gallon	2
TOTAL			17


* To be obtained from Tree of Life Nursery in San Juan Capistrano, CA

IRRIGATION LEGEND

SYMBOL	DESCRIPTION	PSI	GPH	RAD	MFGR/MODEL	DETAILS
●	EMITTER - SHRUB	30	0-13	--	RAIN BIRD SXB-180 XERI-BUBBLER IN DRIPTUBING (NOT SHOWN ON PLAN)	SHEET 6, DETAIL K
■	BUBBLER HEAD - TREE	30	10	--	RAIN BIRD PCT-10 PRESSURE COMPENSATION BUBBLER ON RISER (SHOWN ON PLAN)	SHEET 7, DETAIL A
	MASTER VALVE				SUPERIOR 950 SERIES WLEMA 1600 HE DC SOLENOID ACTUATOR & ADAPTER	SHEET 6, DETAIL B
▼	REMOTE CONTROL VALVE				SUPERIOR 950 SERIES WITH LEMA 1600 HE DC SOLENOID ACTUATOR & ADAPTER	SHEET 6, DETAIL J
⊗	GATE VALVE, LINE SIZE				NIBCO T-113 IR IN VALVE BOX	SHEET 6, DETAIL E
⊙	QUICK COUPLER VALVE				RAIN BIRD 44 LRC IN VALVE BOX	SHEET 6, DETAIL G
⊕	FLUSH VALVE					SHEET 6, DETAIL D
	AUTOMATIC IRRIGATION CONTROLLER				LEIT XRC16 WITH MULTI-PRO REMOTE CONTROL HANDSET STAINLESS STEEL ENCLOSURE. COLUMN MOUNT	SHEET 6, DETAIL I
---	MAIN LINE PIPE, 2", BURIED 24" DEPTH				J-M OR EQUAL, CLASS 315	SHEET 6, DETAIL A
---	PVC LATERAL PIPE, SIZE AS SHOWN, BURIED 12" DEPTH				J-M OR EQUAL, SCH 40	SHEET 6, DETAIL A
---	POLYETHYLENE PIPE, ON-GRADE, SIZE AS SHOWN, BROWN, 3/4"				RAINBIRD POLY TUBING	SHEET 6, DETAIL A
---	PVC SLEEVE, 2x DIAM OF CARRYING PIPE, MIN.				J-M OR EQUAL, SCH 40	SHEET 6, DETAIL A


IRRIGATION/ PLANTING PLAN

DESIGNED BY:		REVISIONS					CITY OF PASADENA - DEPARTMENT OF PUBLIC WORKS						
DRAWN BY:		MARK	DATE	DESCRIPTION	BY	CHKD.	APPROVED	PROJECT		LOWER ARROYO SECO / VAN DE KAMP BRIDGE HABITAT RESTORATION PROJECT		SHEET 4 OF 8	
								LIMITS		-		DWG. NO. #	
								SCALE		1"=30'		ACCOUNT NO. -	
CHECKED BY:				AS BUILT									

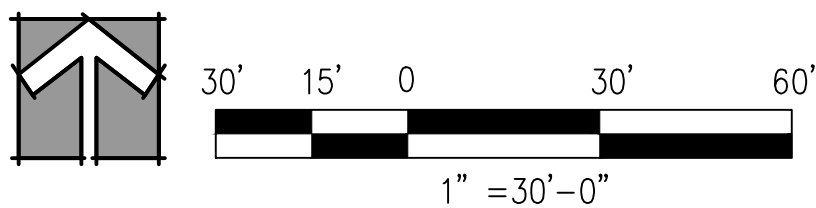

CORNERSTONE STUDIOS, INC.
951 E Santa Ana Blvd. 714. 973. 2200 Voice
Santa Ana, CA 92701 714. 973. 0203 Fax

LANDSCAPE ARCHITECTURE • URBAN DESIGN • PLANNING • RESOURCE ANALYSIS

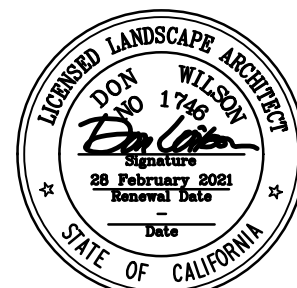

MATCH LINE, SEE SHEET-4

LEGEND

NO PLANTING (NON-WORK AREAS) (2.59 ACRES)

REST AREAS - 6" MULCH MIN. (0.38 ACRE)

BUFFER WEED REMOVAL AREAS (1.06 ACRES)

PLANTING AREAS - EAST - 3" MULCH MIN. (0.58 ACRE)

SOIL DECOMPACTION (0.14 ACRE)

WALNUT WOODLAND PLANTING AREA - 3" MULCH MIN. (0.2 ACRE)

PLANTING AREA - WEST - 3" MULCH MIN. (0.36 ACRE)

PLANTING AREA - RIPARIAN NORTH - 3" MULCH MIN. (0.54 ACRE)

PLANTING AREA - RIPARIAN SOUTH - 3" MULCH MIN. (0.21 ACRE)

PLANTING AREA - SOUTH - 3" MULCH MIN. (0.16 ACRE)

5FT. VEGETATION REMOVAL ALONG FENCE

CACTUS/YUCCA PLANTING AREA - NO MULCH (0.19 ACRE)

PROPOSED MOUNDS

BOULDER EDGING

WESTERN SYCAMORE PLANTING (15-Gallon)

PLANT TABLE			
PLANTING AREA	PLANT SPECIES	SIZE	QUANTITY
West	Various	1-Gallon	226
East	Various	1-Gallon	550
Walnut Woodland	Various	1-Gallon	220
Cactus/Yucca	Various	1-Gallon	205
South	Various	1-Gallon	131
Riparian North	Various	1-Gallon	587
Riparian South	Various	1-Gallon	81
TOTAL			2,000
Riparian	Western Sycamore (Platanus racemosa)*	15-Gallon	15
Riparian South	Western Sycamore (Platanus racemosa)*	15-Gallon	2
TOTAL			17

* To be obtained from Tree of Life Nursery in San Juan Capistrano, CA

IRRIGATION LEGEND					
SYMBOL	DESCRIPTION	PSI	GPH	RAD	MFGR/MODEL
●	EMITTER - SHRUB	30	0-13	--	RAIN BIRD SXB-180 XERI-BUBBLER IN DRIPTUBING (NOT SHOWN ON PLAN)
■	BUBBLER HEAD - TREE	30	10	--	RAIN BIRD PCT-10 PRESSURE COMPENSATION BUBBLER ON RISER (SHOWN ON PLAN)
MM	MASTER VALVE				SUPERIOR 950 SERIES W/LEMA 1600 HE DC SOLENOID ACTUATOR & ADAPTER
▼	REMOTE CONTROL VALVE				SUPERIOR 950 SERIES WITH LEMA 1600 HE DC SOLENOID ACTUATOR & ADAPTER
⊗	GATE VALVE, LINE SIZE				NIBCO T-113 IR IN VALVE BOX
⊙	QUICK COUPLER VALVE				RAIN BIRD 44 LRC IN VALVE BOX
Ⓟ	FLUSH VALVE				
Ⓜ	AUTOMATIC IRRIGATION CONTROLLER				LEIT XRC16 WITH MULTI-PRO REMOTE CONROL HANDSET STAINLESS STEEL ENCLOSURE. COLUMN MOUNT
---	MAIN LINE PIPE, 2", BURIED 24" DEPTH EXCEPT AS SHOWN				J-M OR EQUAL, CLASS 315
---	PVC LATERAL PIPE, SIZE AS SHOWN, BURIED 12" DEPTH				J-M OR EQUAL, SCH 40
---	POLYETHYLENE PIPE, ON-GRADE, SIZE AS SHOWN, BROWN, 3/4"				RAINBIRD POLY TUBING
---	PVC SLEEVE, 2x DIAM OF CARRYING PIPE, MIN.				J-M OR EQUAL, SCH 40

STATION NUMBER



RCV SIZE

GPM

PLANT TYPE

IRRIGATION PIPE SIZING CHART
(GPM @5 FEET/SECOND)

SYMBOLS	PIPE SIZE	PVC CL 315	PVC SCH 40
I	3/4"		8.3
II	1"		13.5
III	1-1/4"		23.4
IIII	1-1/2"		31.8
IIIII	2"	50.0	52.4
IIIII	2-1/2"	73.6	74.9
IIIII	3"	109.2	115.5

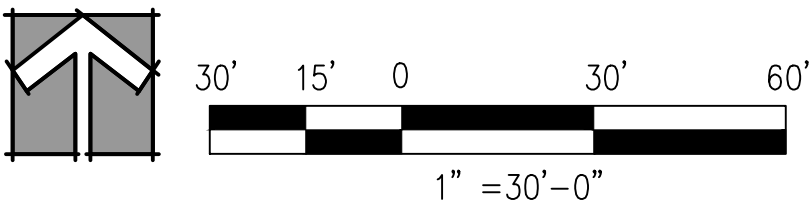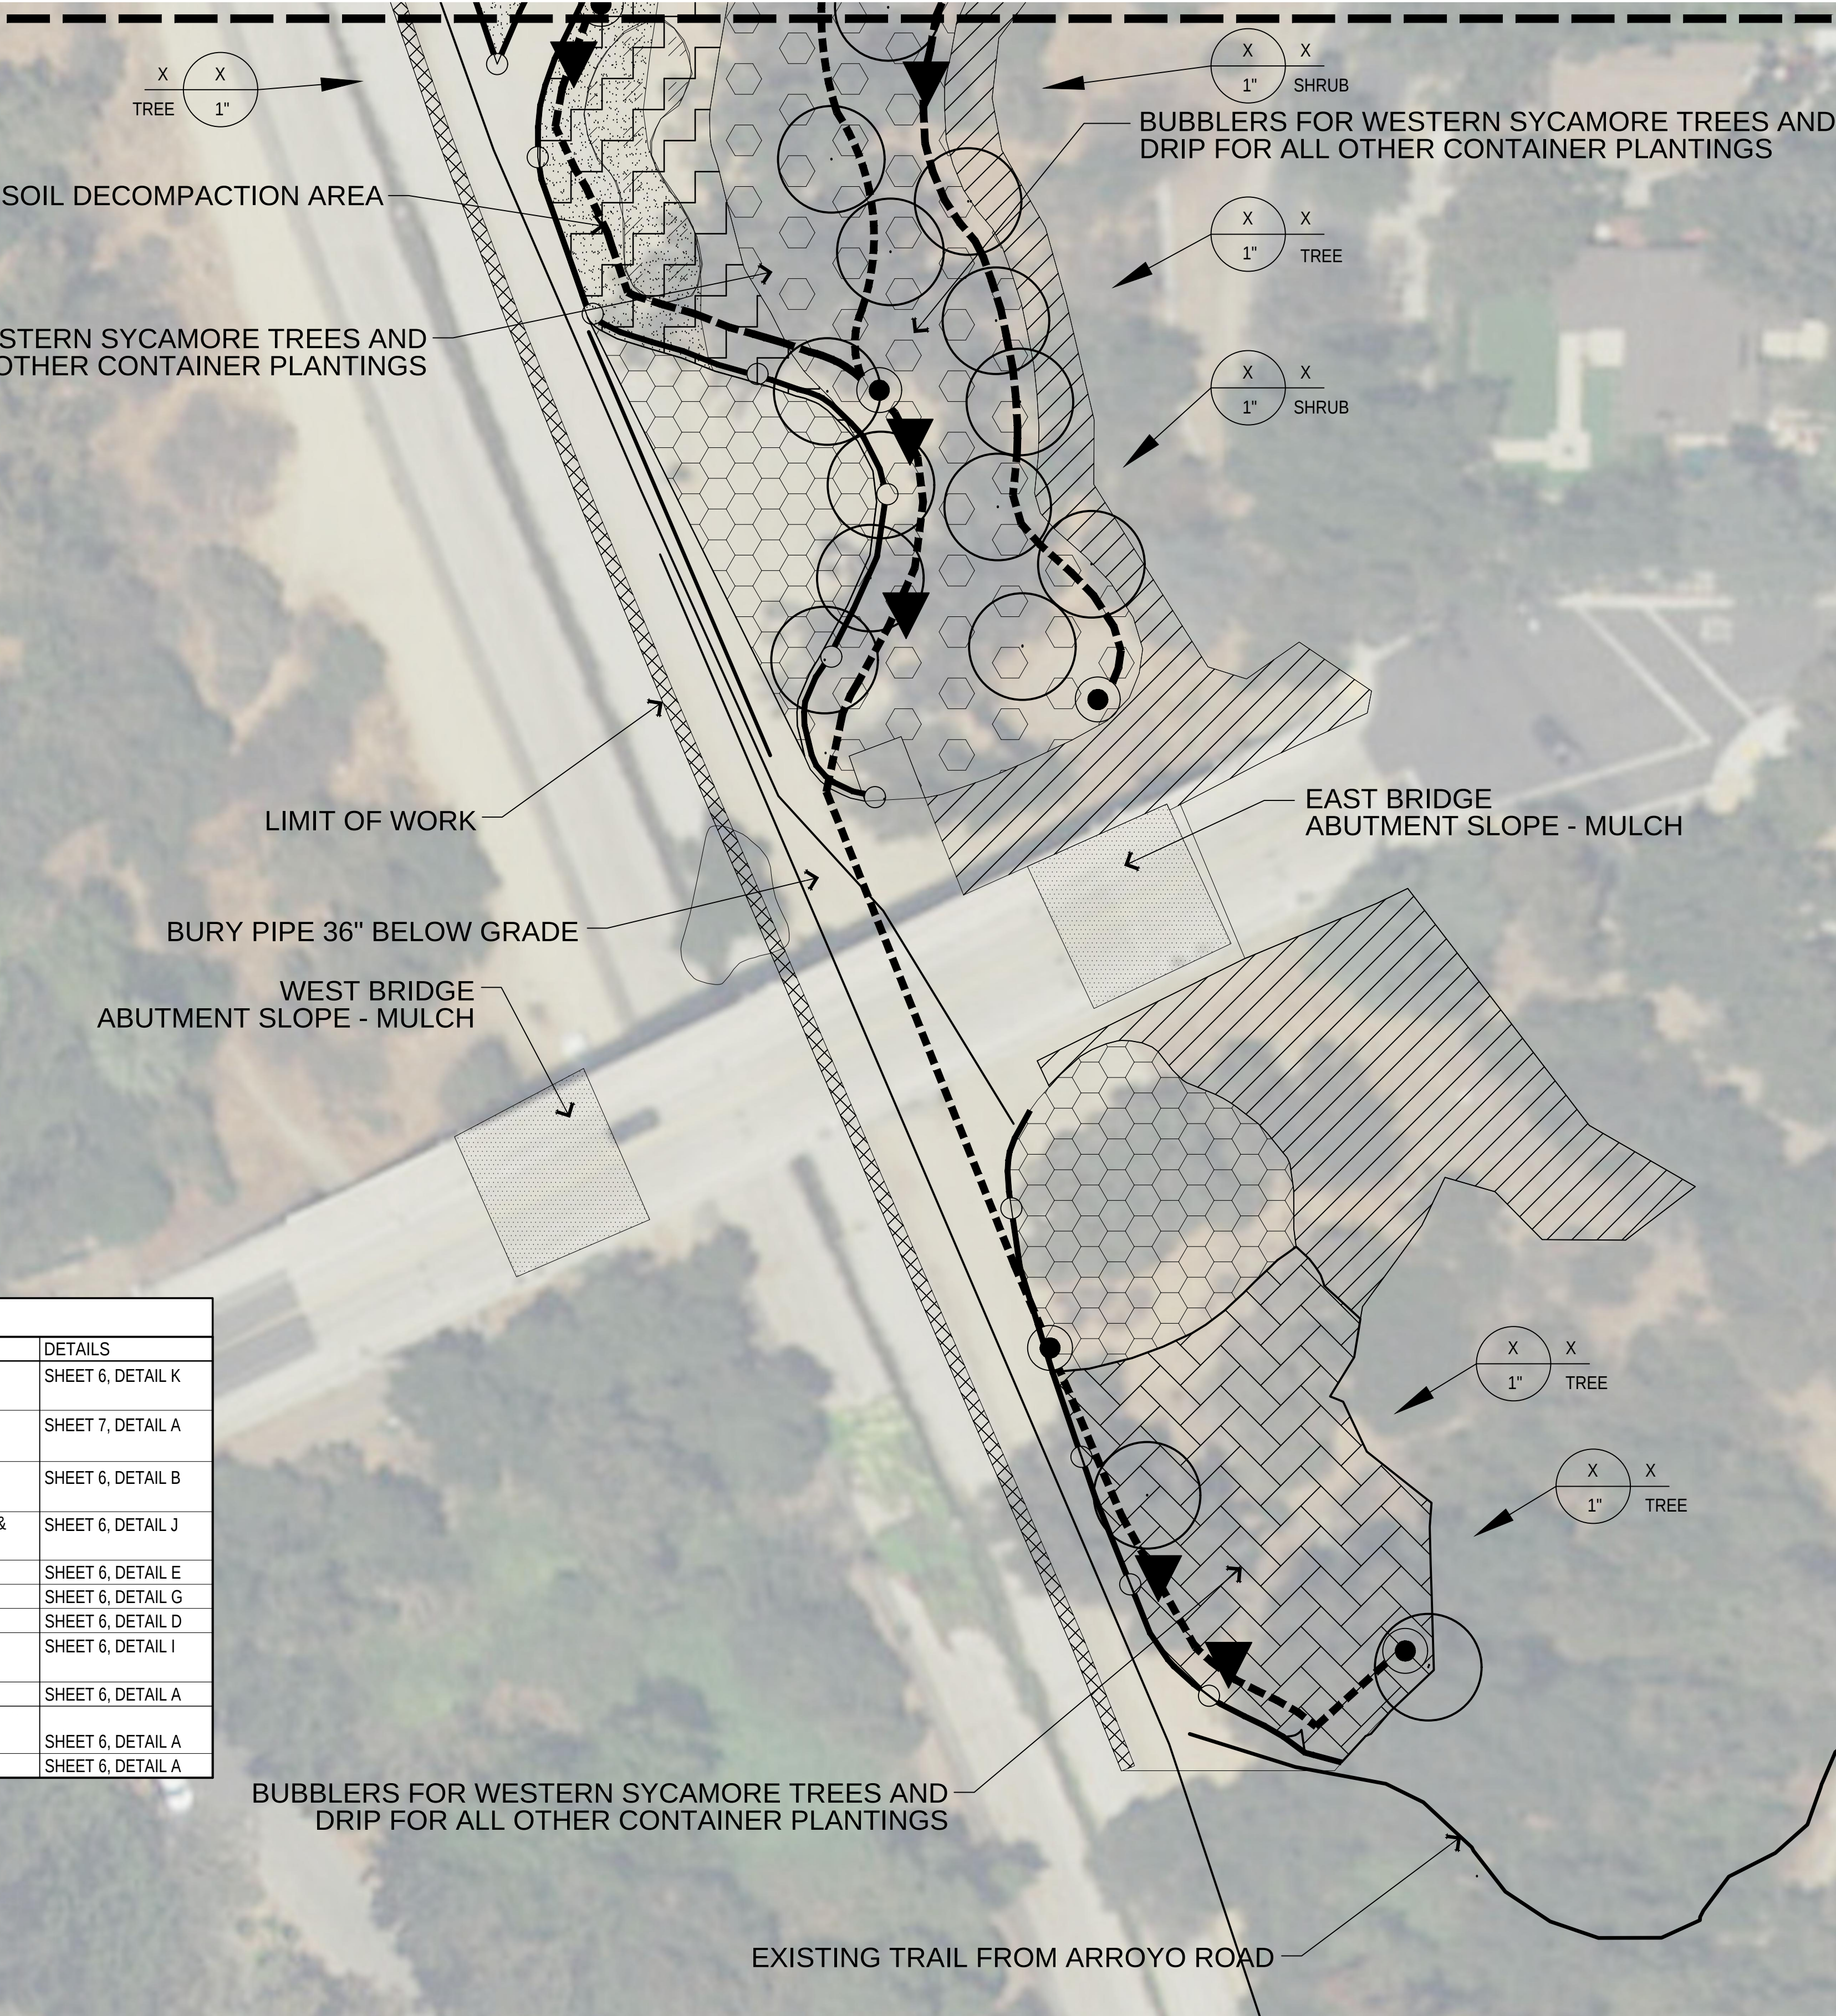


CORNERSTONE STUDIOS, INC.
951 E Santa Ana Blvd. 714. 973. 2200 Voice
Santa Ana, CA 92701 714. 973. 0203 Fax
LANDSCAPE ARCHITECTURE • URBAN DESIGN • PLANNING • RESOURCE ANALYSIS




DESIGNED BY:		REVISIONS					CITY OF PASADENA - DEPARTMENT OF PUBLIC WORKS		
DRAWN BY:		MARK	DATE	DESCRIPTION	BY	CHKD.	APPROVED	PROJECT	SHEET 5 OF 8
CHECKED BY:								LIMITS -	DWG. #
				AS BUILT				SCALE 1"=30'	ACCOUNT NO. -

IRRIGATION/ PLANTING PLAN

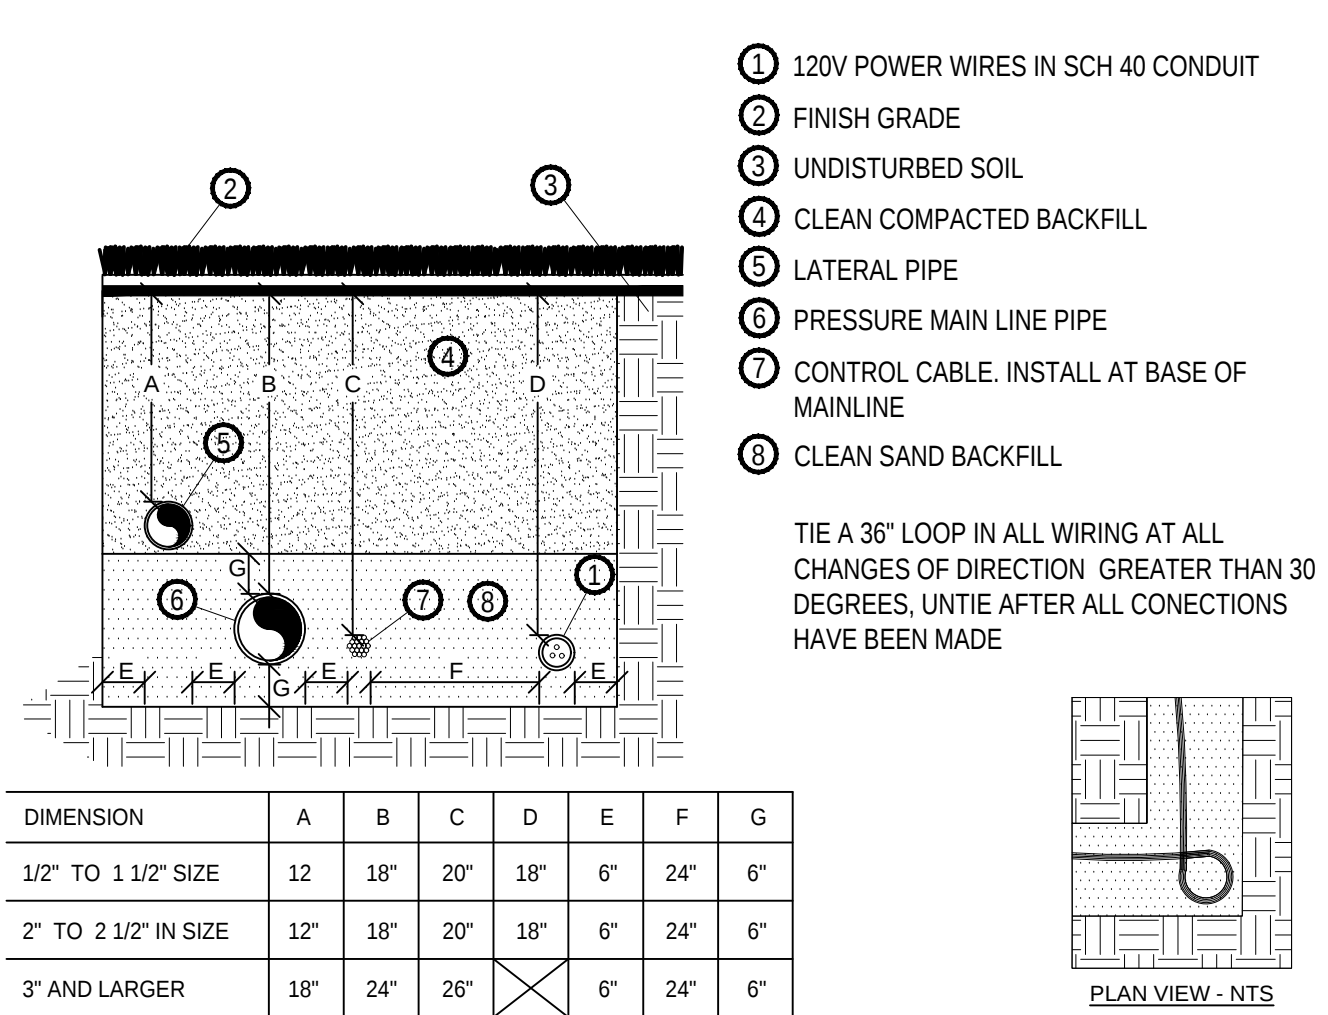


SNAKE ALL PLASTIC PIPING WITHIN TRENCHES
INSTALL ALL PIPE IN ACCORD WITH MANUFACTURERS SPECIFICATIONS


A PIPE & WIRE TRENCHING NTS

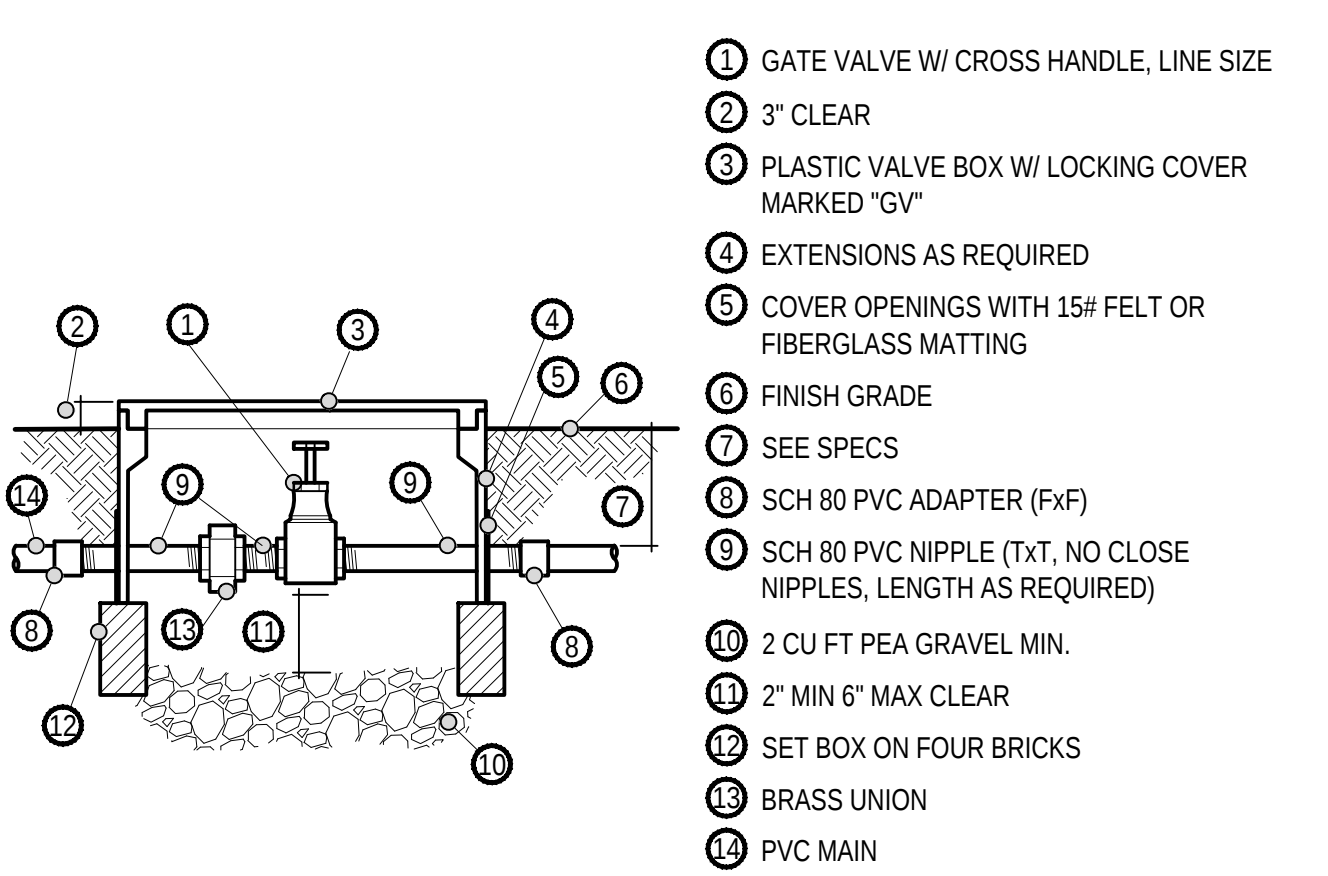


E GATE VALVE 2 1/2" AND SMALLER NTS

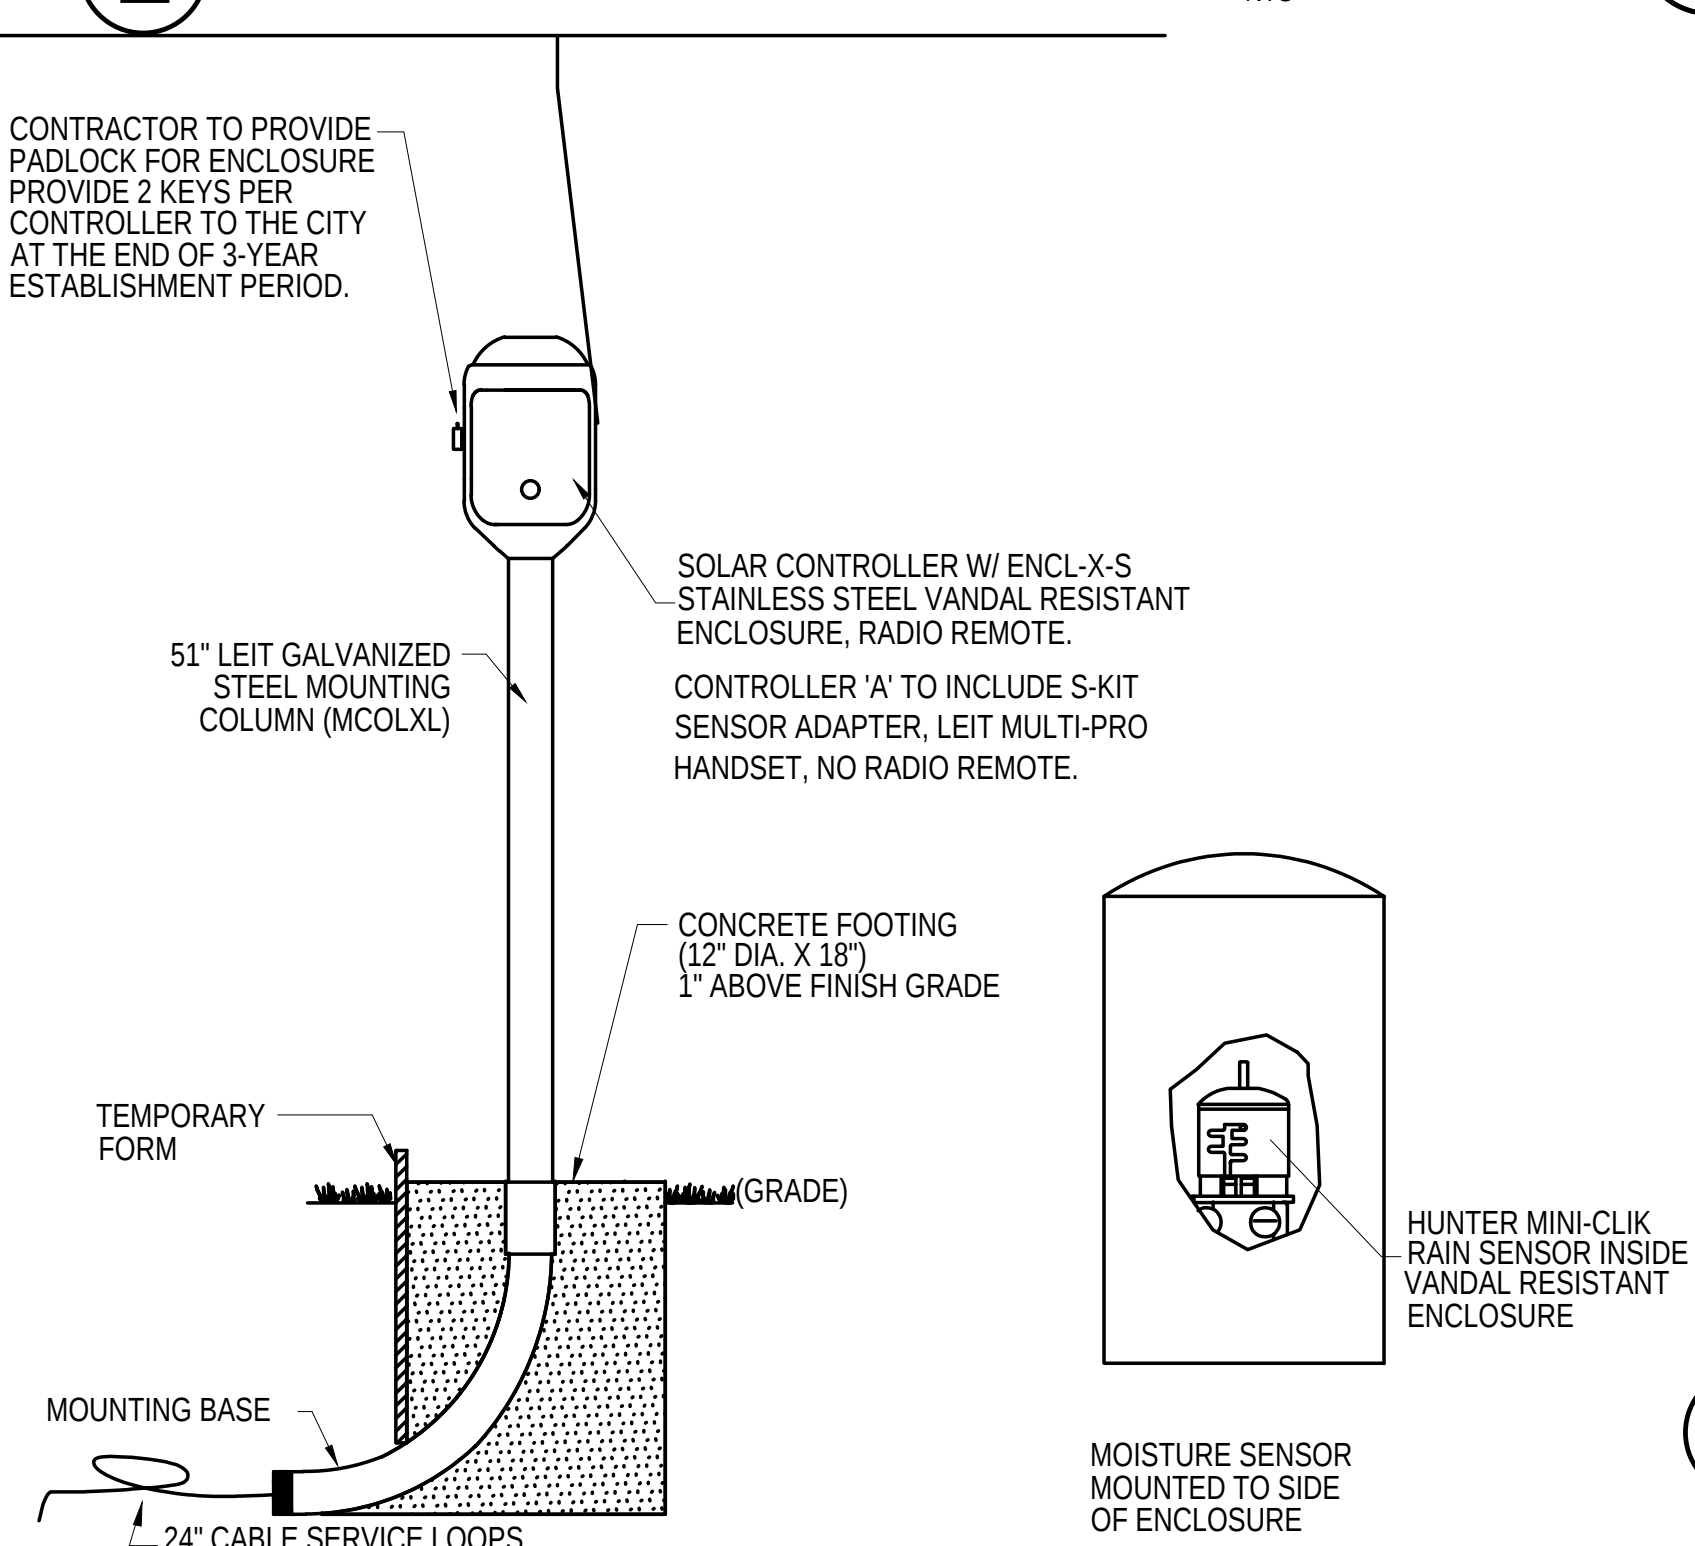


I SOLAR IRRIGATION CONTROLLER NTS

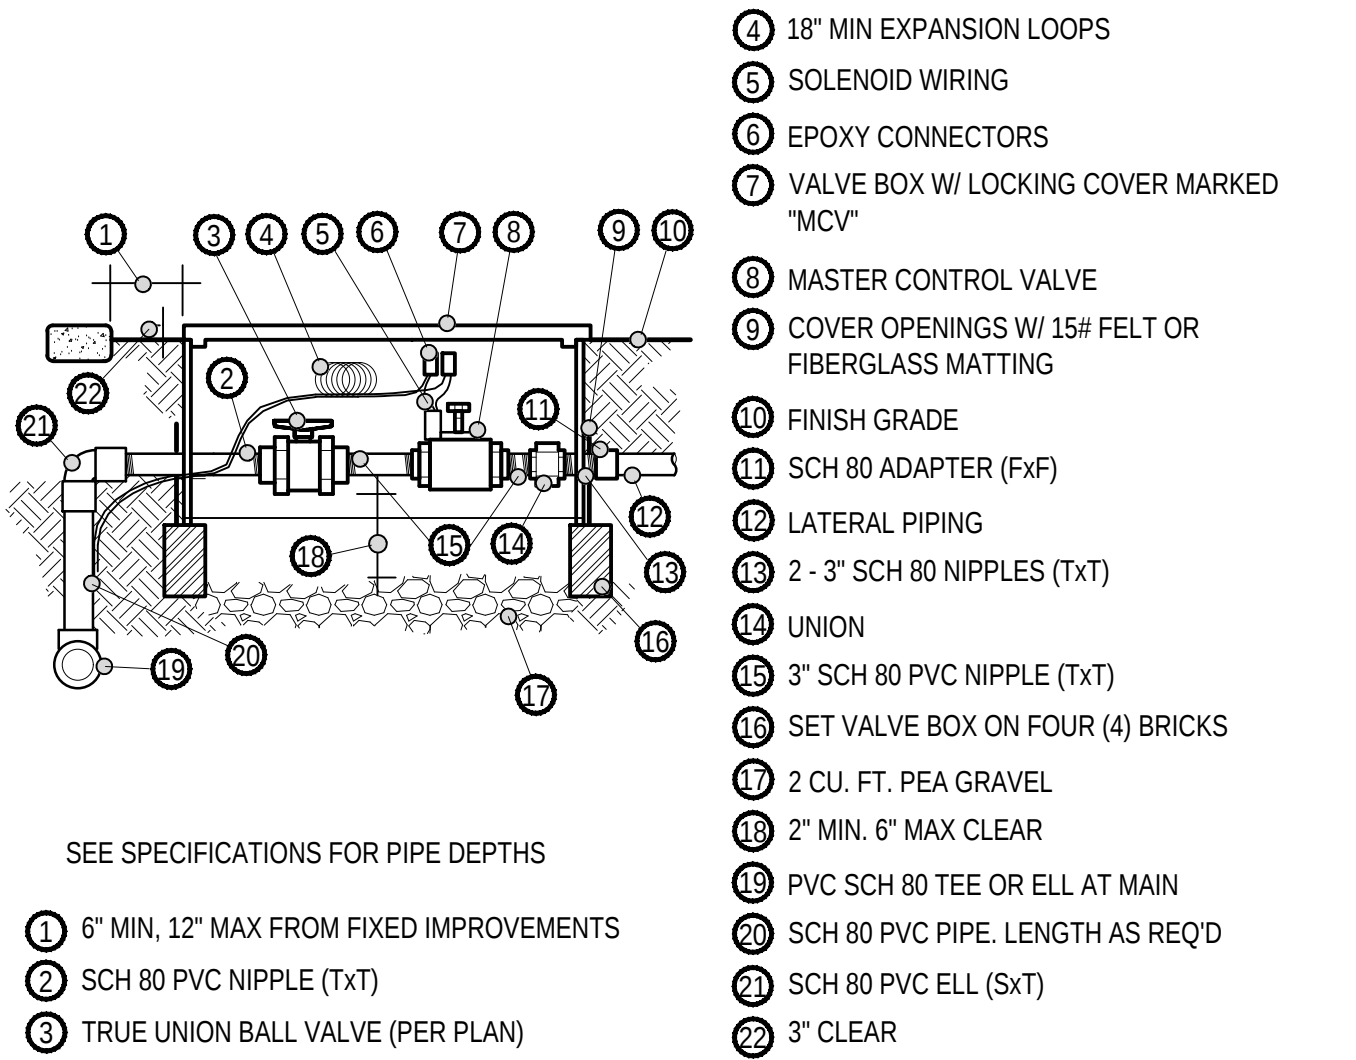


B MASTER CONTROL VALVE NTS

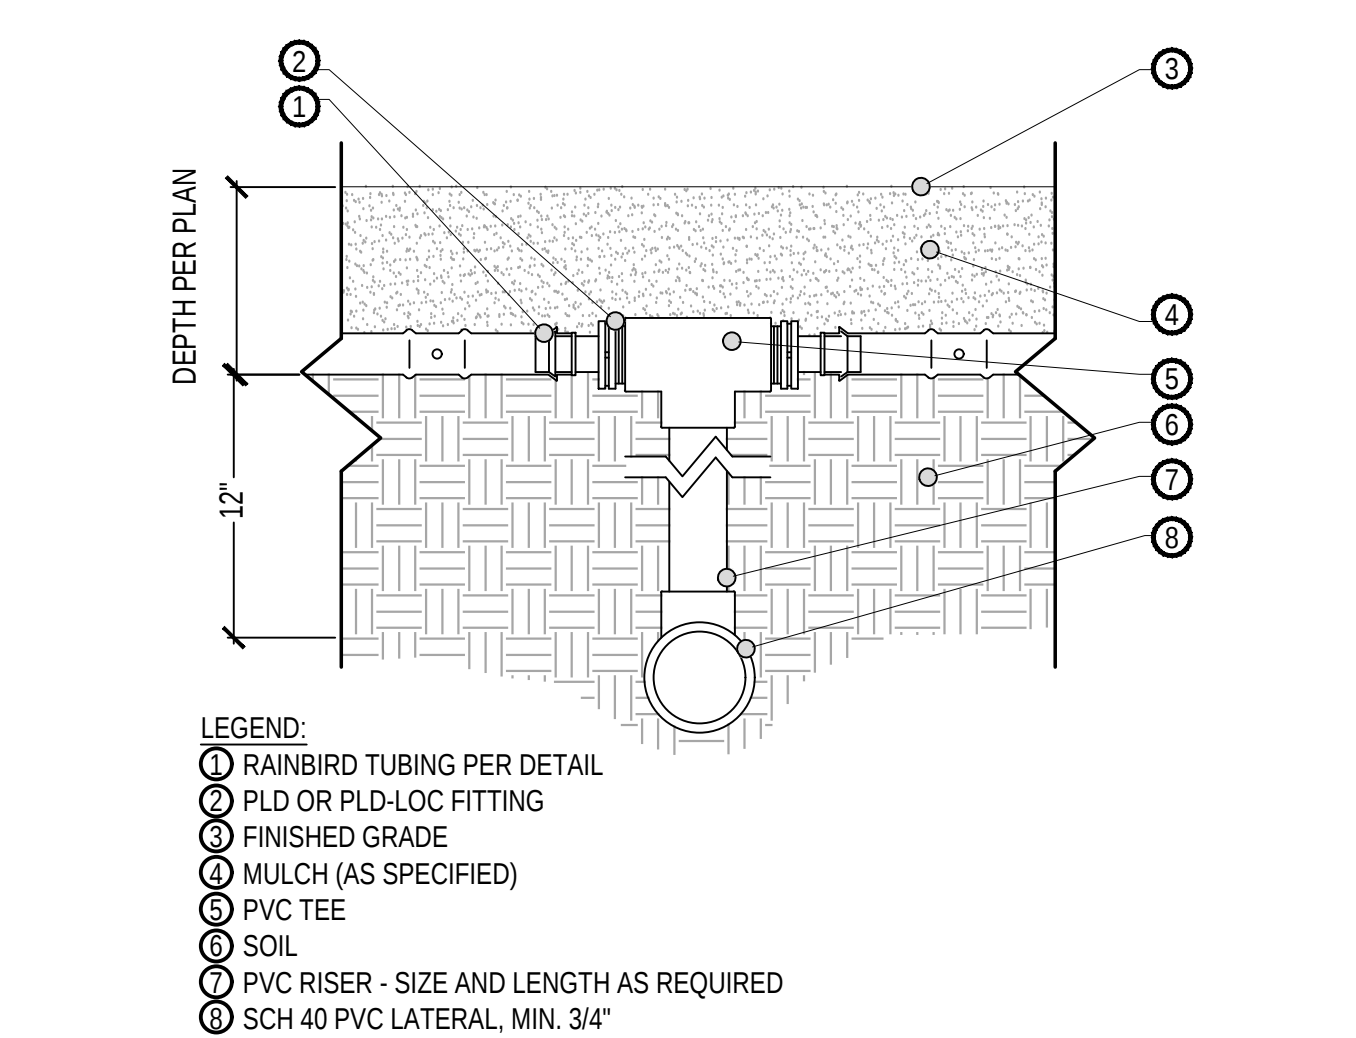


F CONNECTION TO PVC LATERAL LINE WITH PVC RISER AND TEE NTS

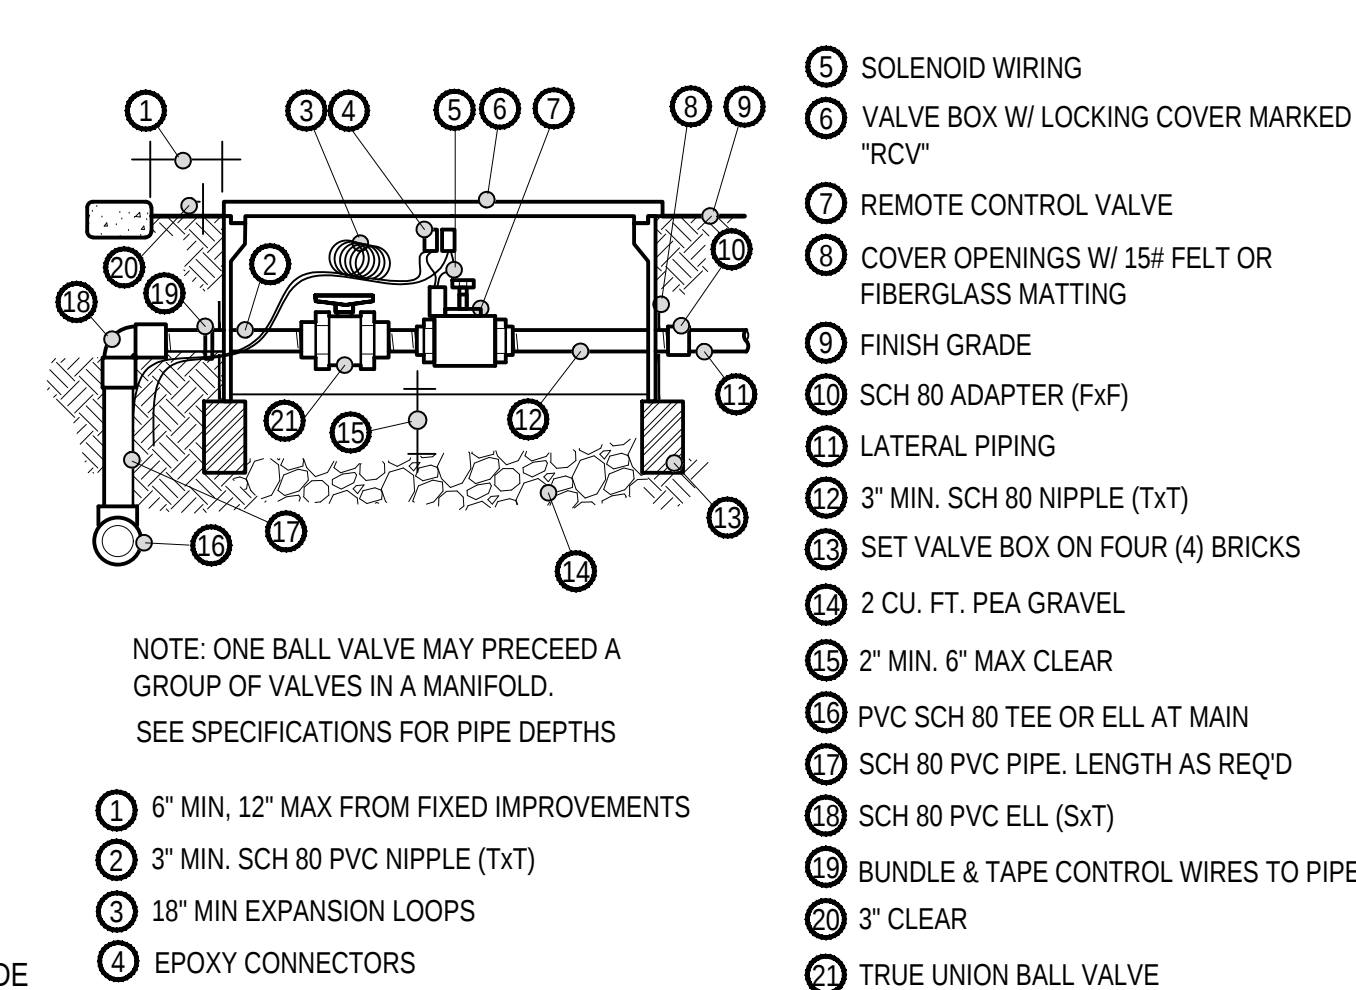


J REMOTE CONTROL VALVE NTS

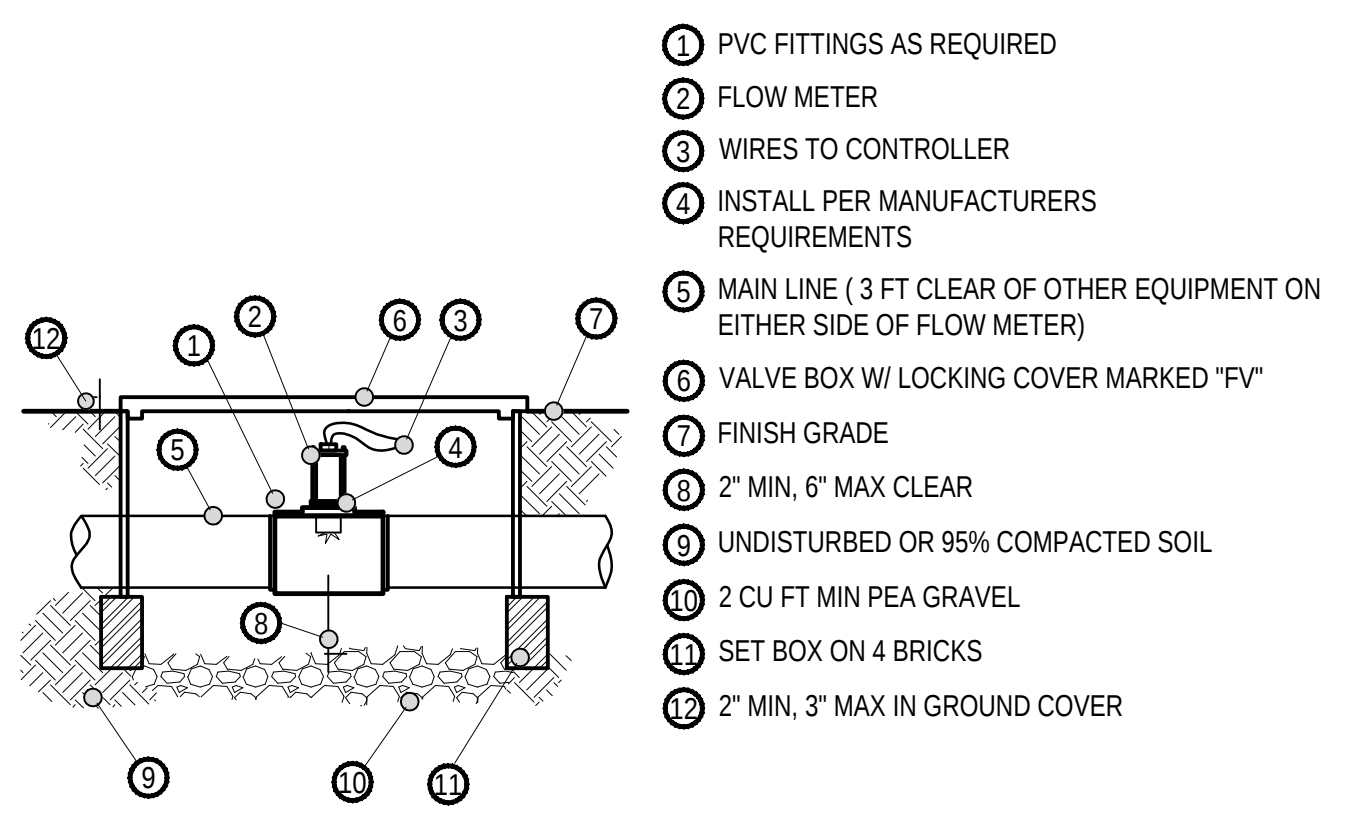


C FLOW SENSOR NTS

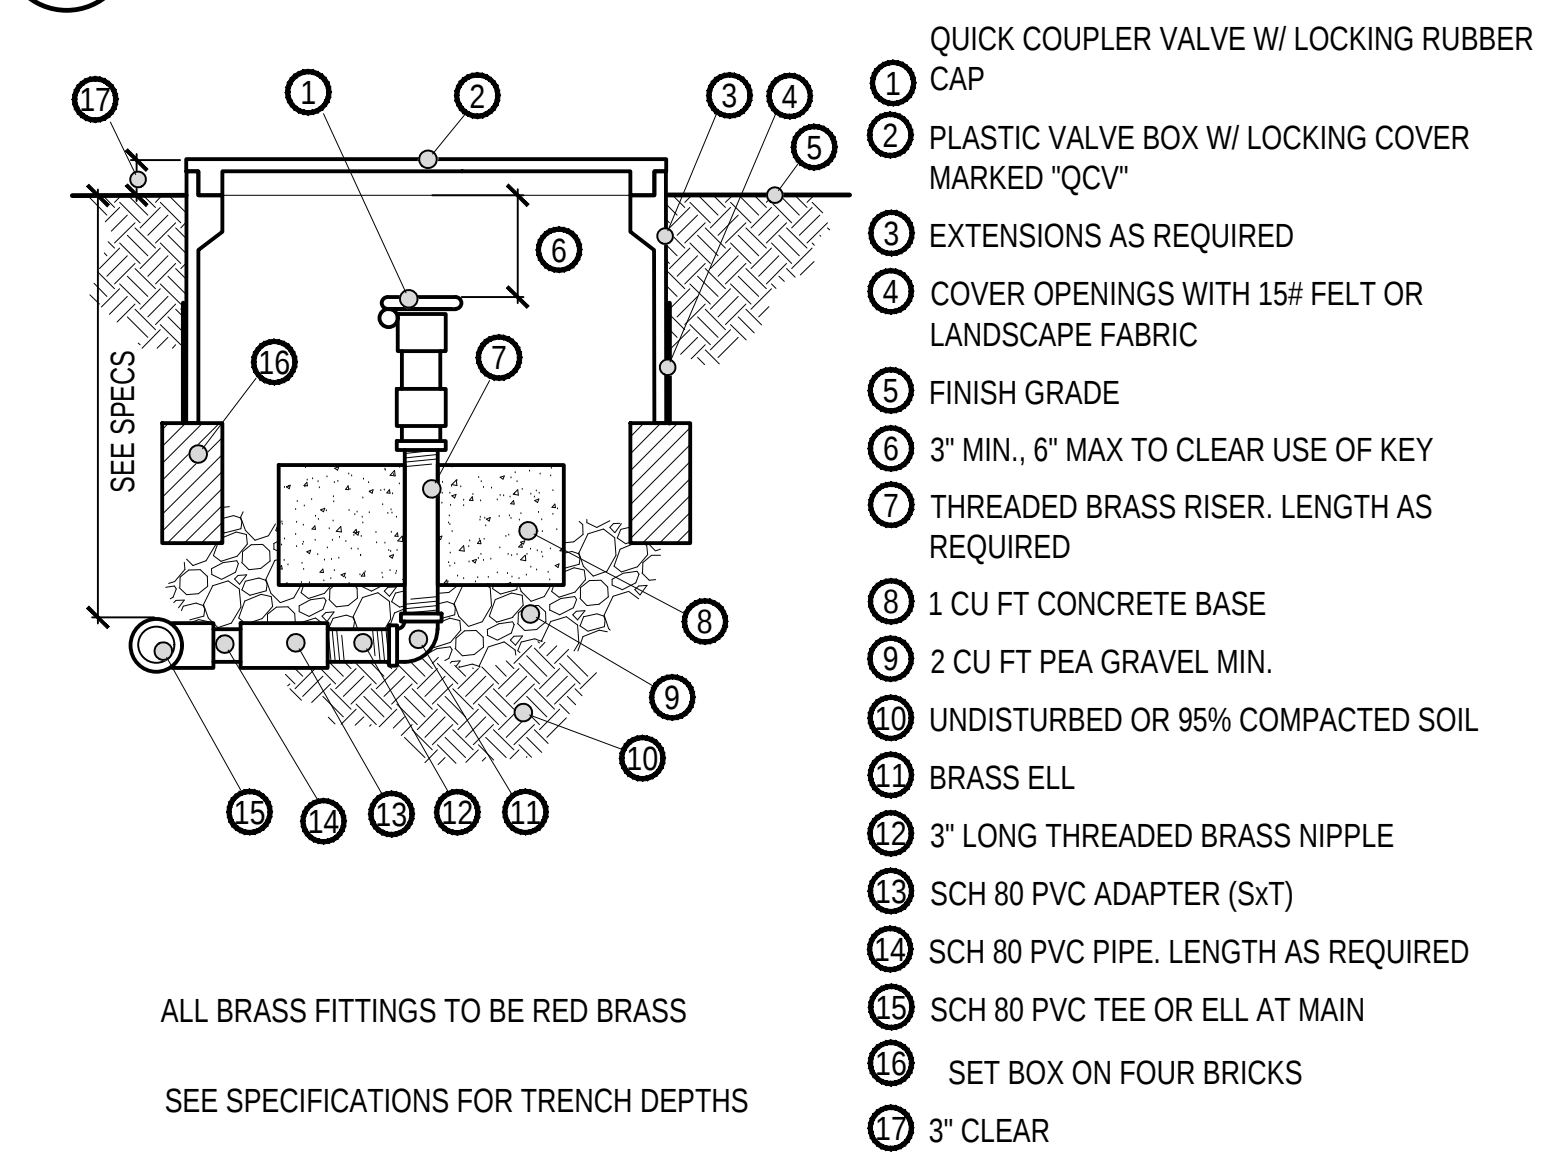


G QUICK COUPLER VALVE NTS

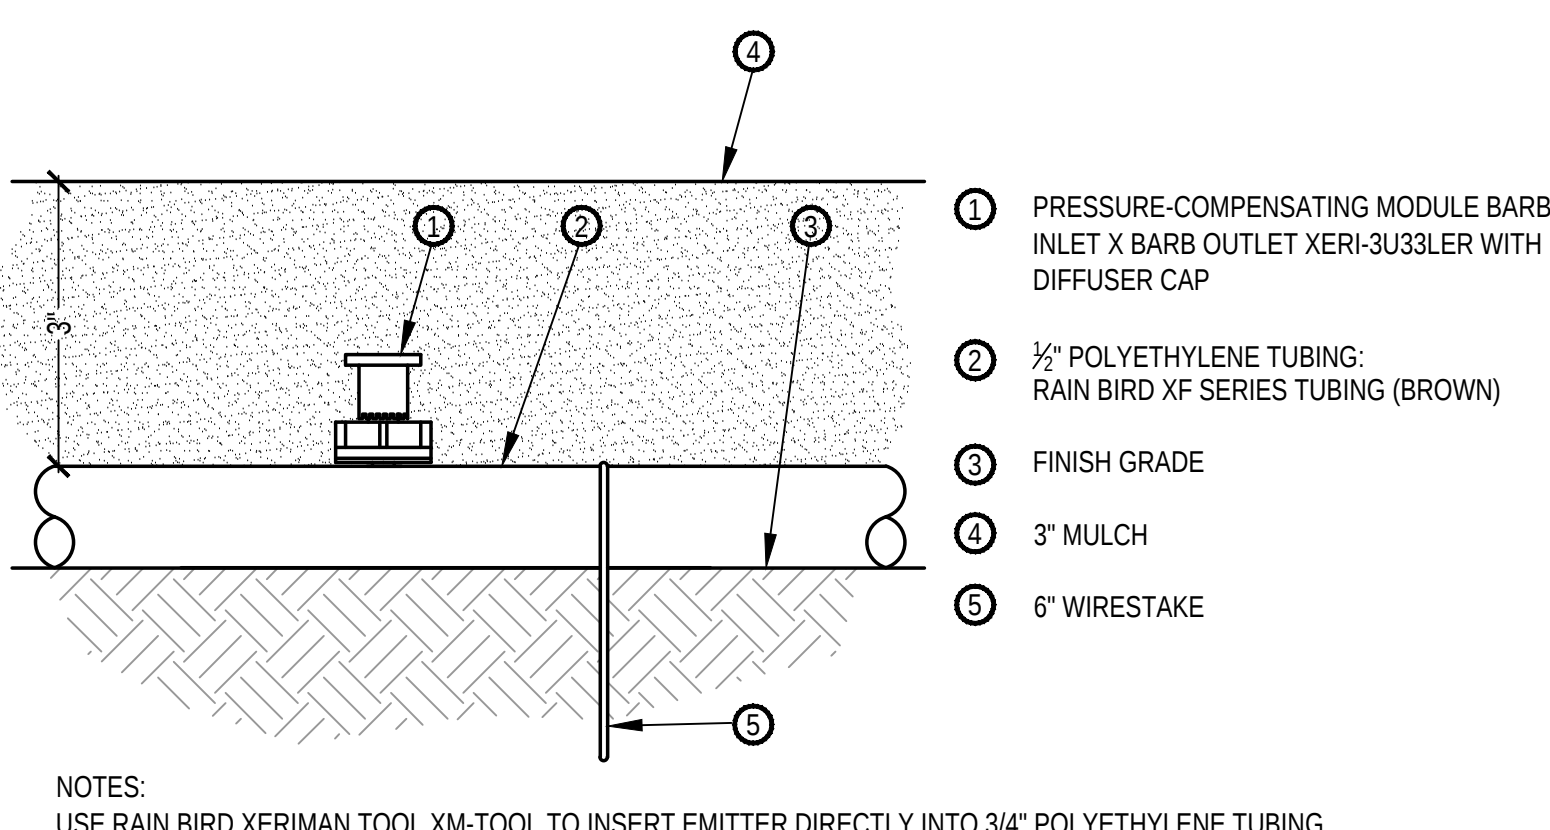

K EMITTER: PRESSURE-COMPENSATING XERI-3U33LER DIFFUSER CAP INTO 1/2-INCH TUBING NTS

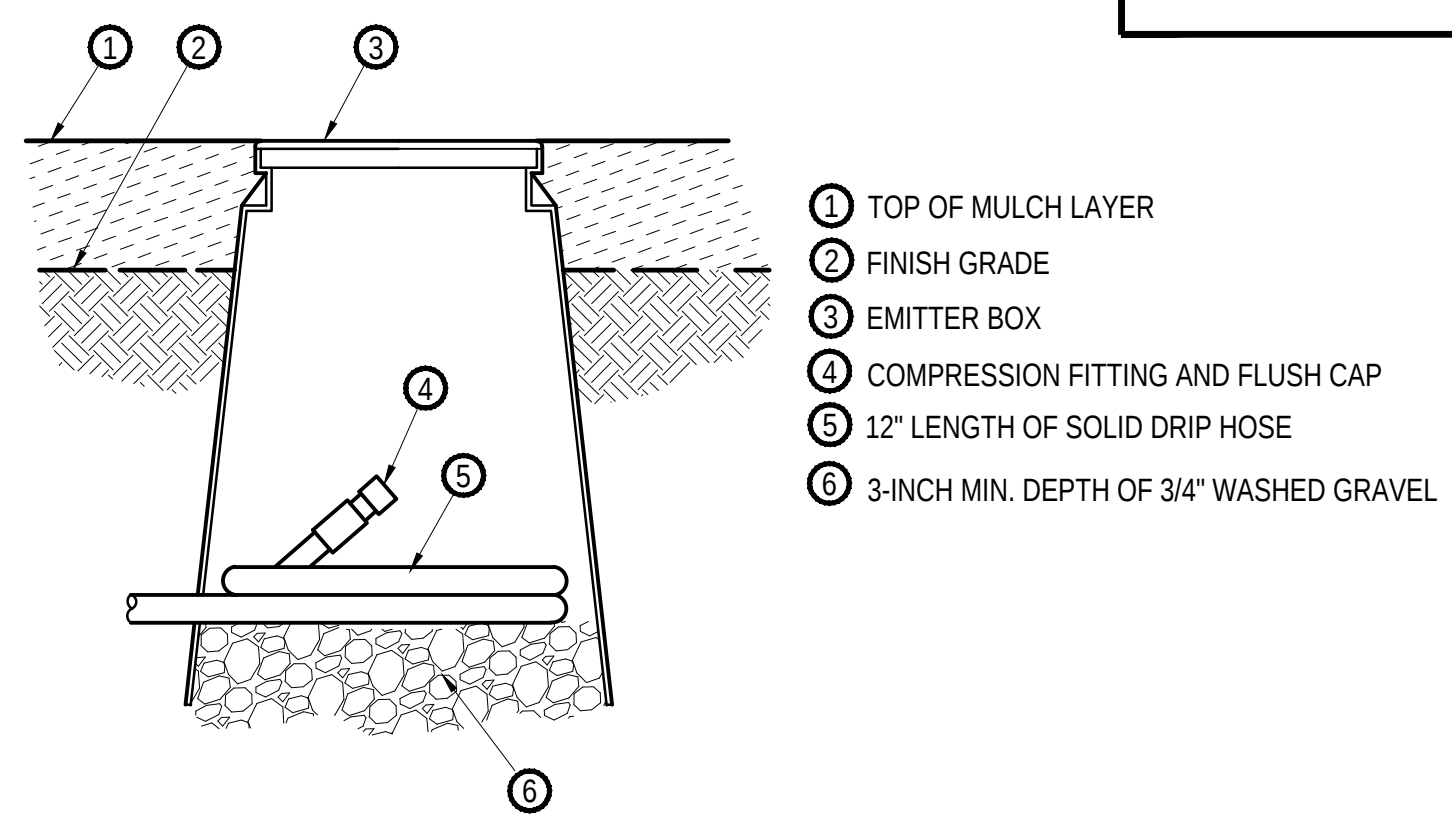


D FLUSH VALVE NTS

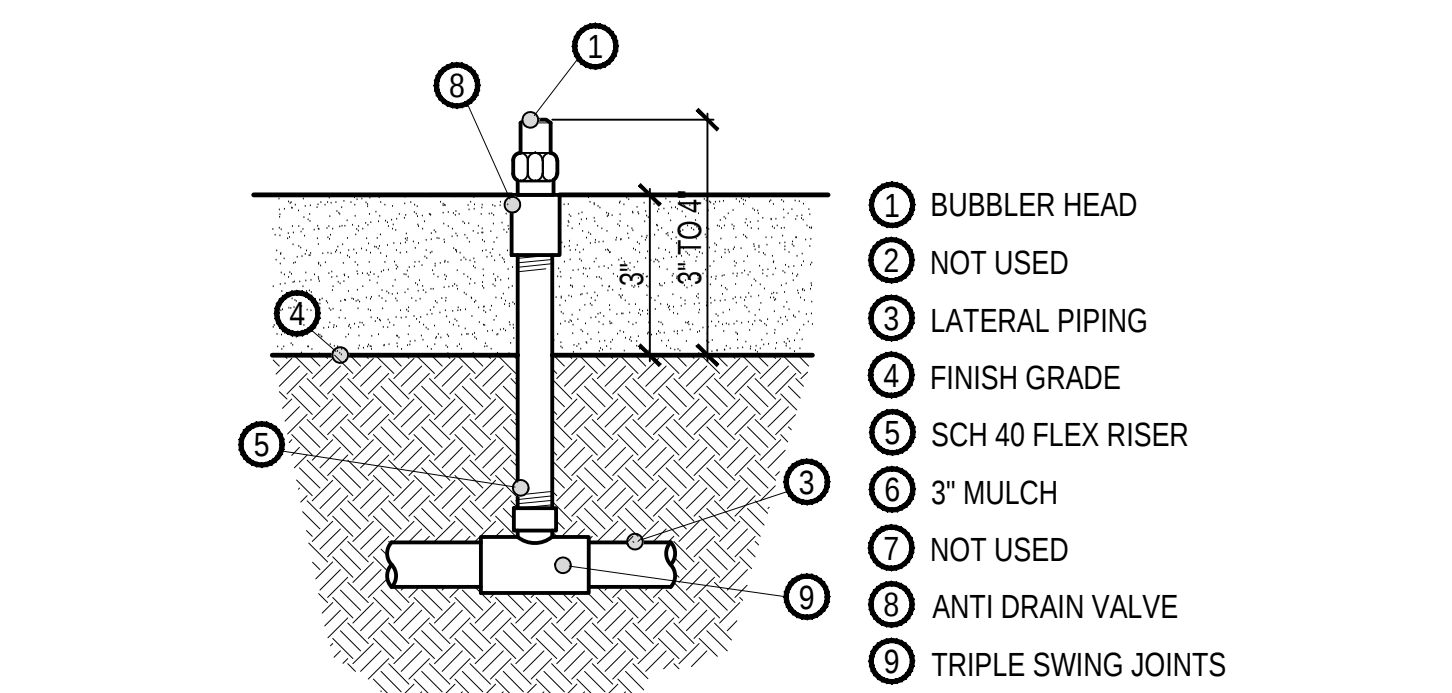


H BUBBLER HEAD WITH FLEX RISER (BURIED) NTS

SUBMITTED

CORNERSTONE STUDIOS, INC.
951 E Santa Ana Blvd. 714. 973. 2200 Voice
Santa Ana, CA 92701 714. 973. 0203 Fax

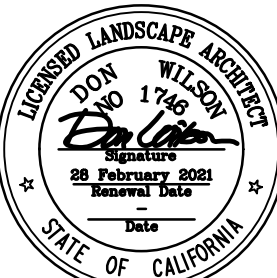



DESIGNED BY:		REVISIONS					CITY OF PASADENA - DEPARTMENT OF PUBLIC WORKS		
DRAWN BY:		MARK	DATE	DESCRIPTION	BY	CHKD.	APPROVED	PROJECT	SHEET 6 OF 8
CHECKED BY:								LIMITS -	DWG. NO. #
				AS BUILT				SCALE AS NOTED	ACCOUNT NO. -

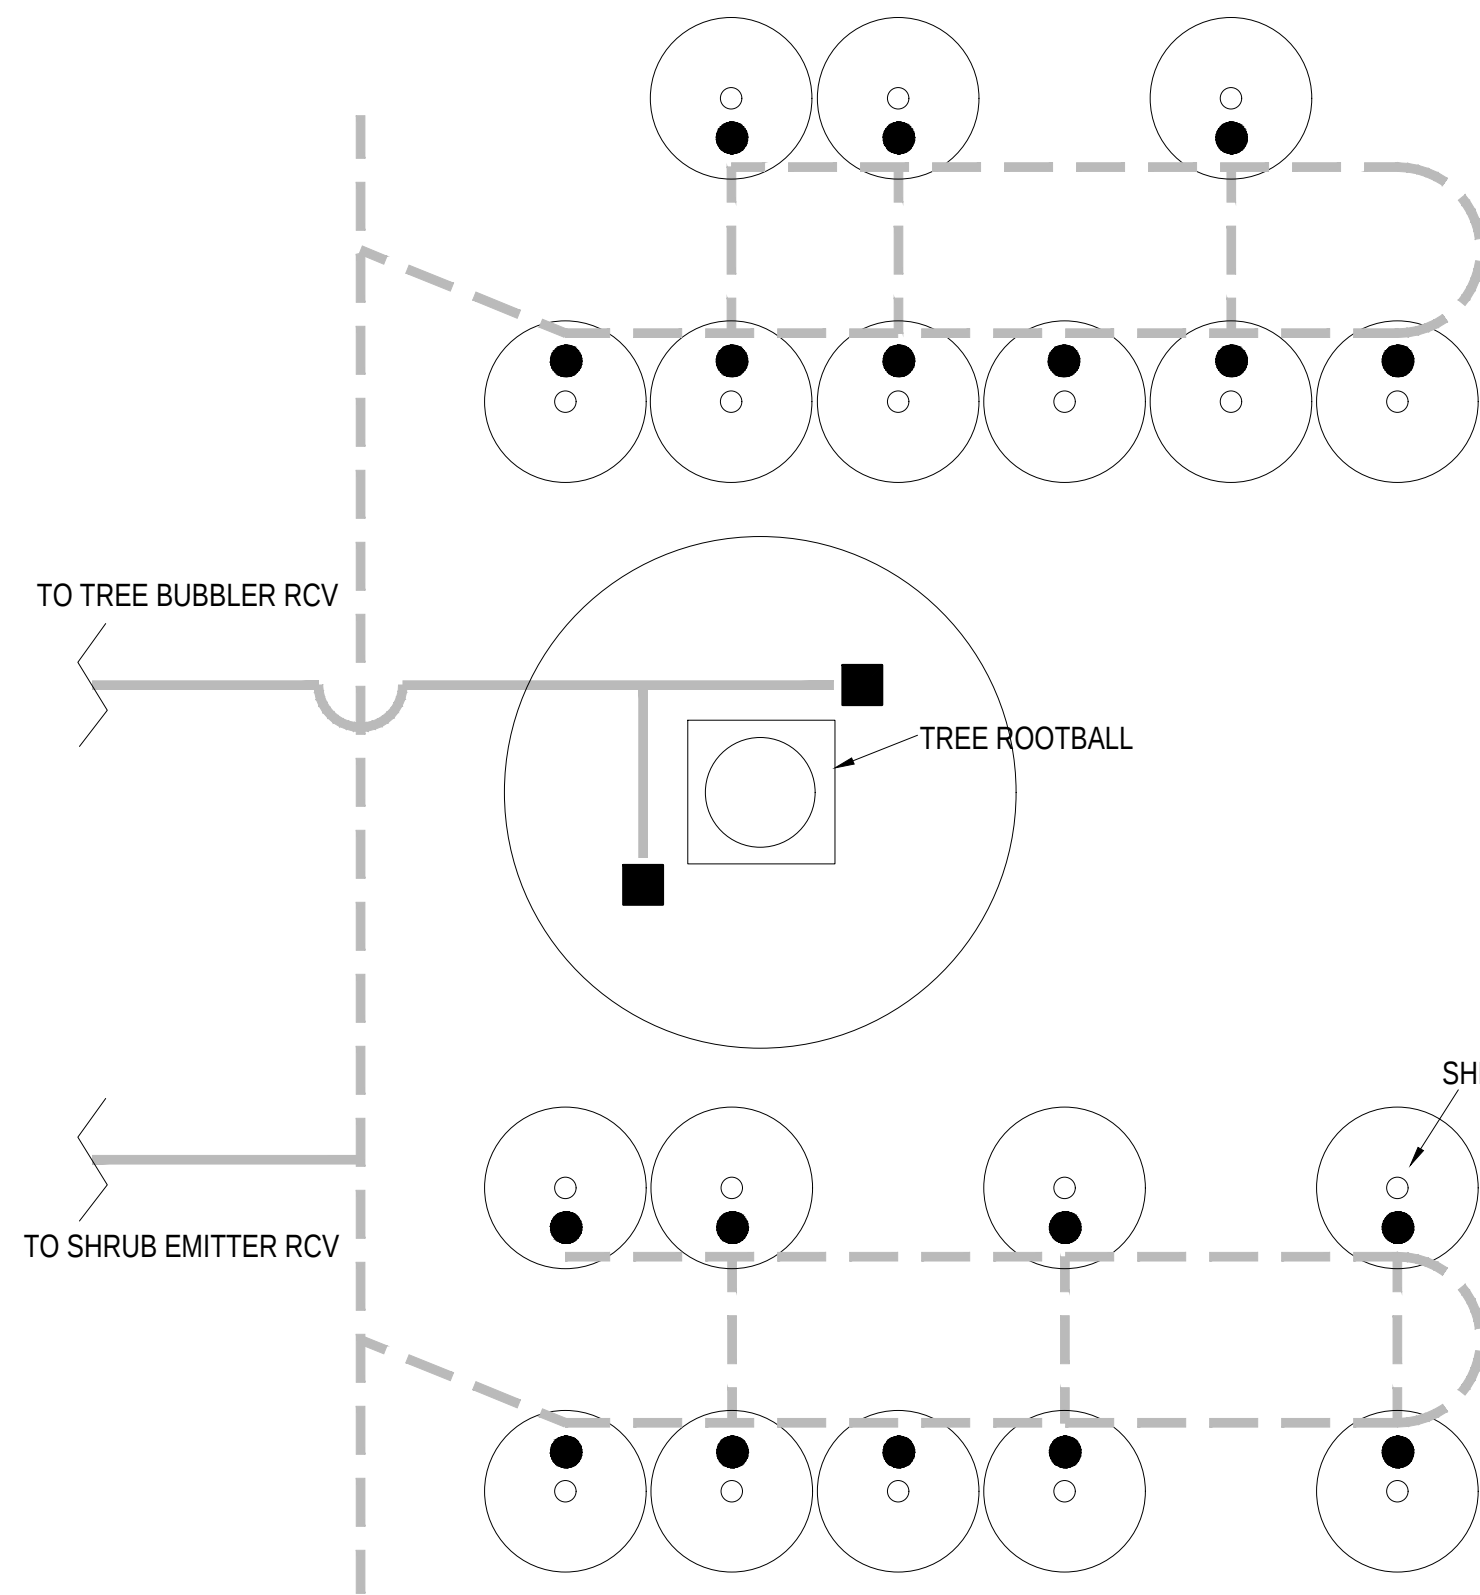


IRRIGATION LEGEND

- BUBBLER HEAD - SHRUB
- BUBBLER HEAD - TREE
- LATERAL PIPE, BURIED, SIZE AS SHOWN
- - - DRIP TUBING ON GRADE

A BUBBLER LAYOUT NTS

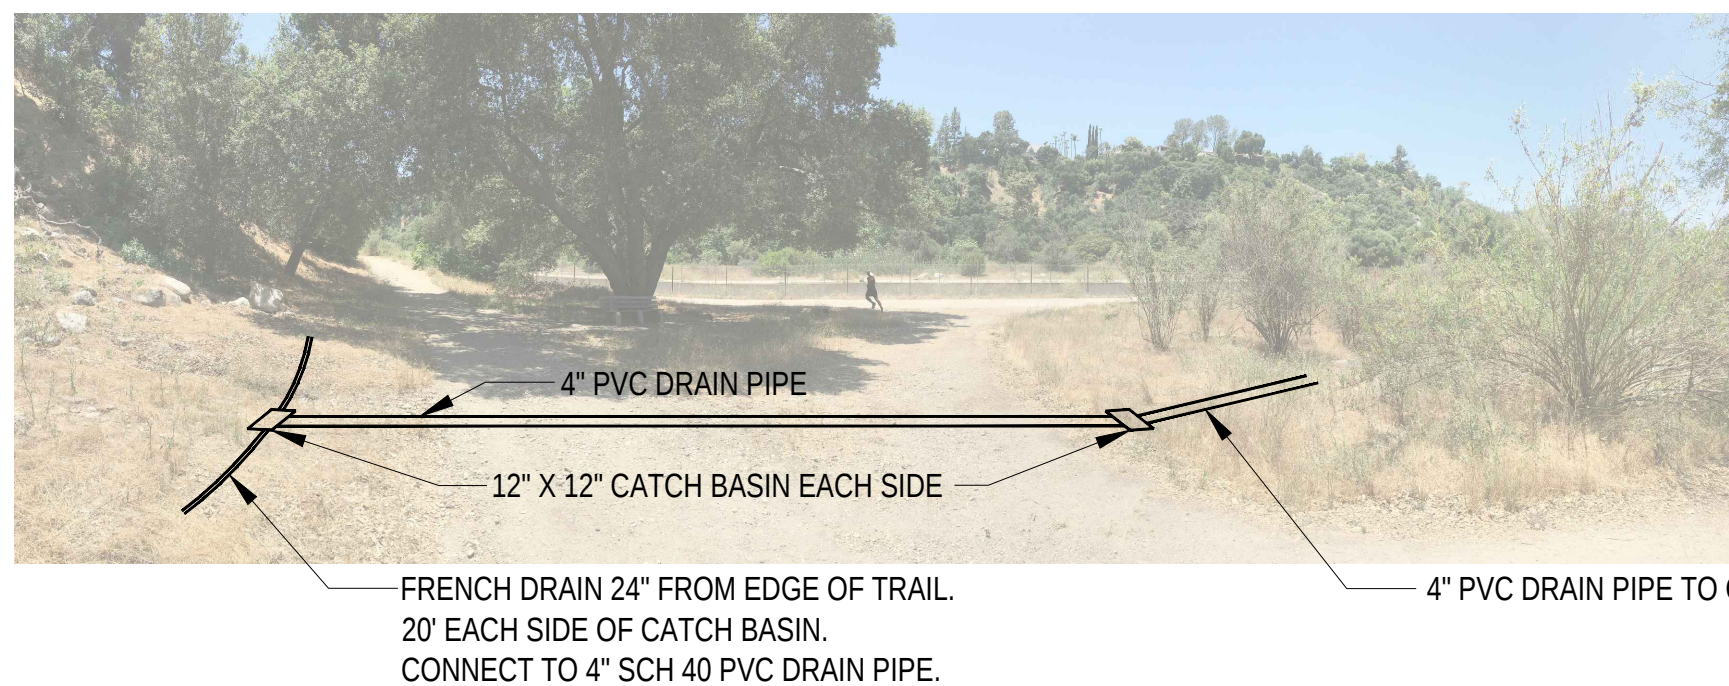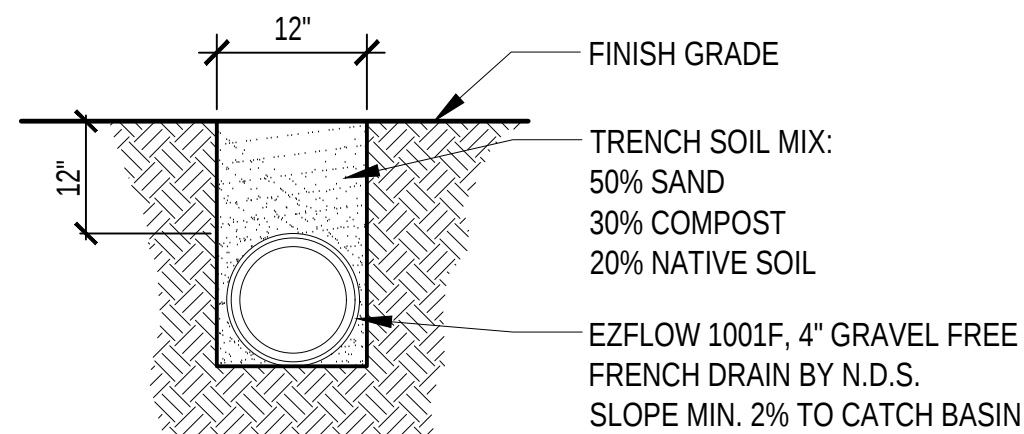


B FRENCH DRAIN SECTION / ELEVATION NTS

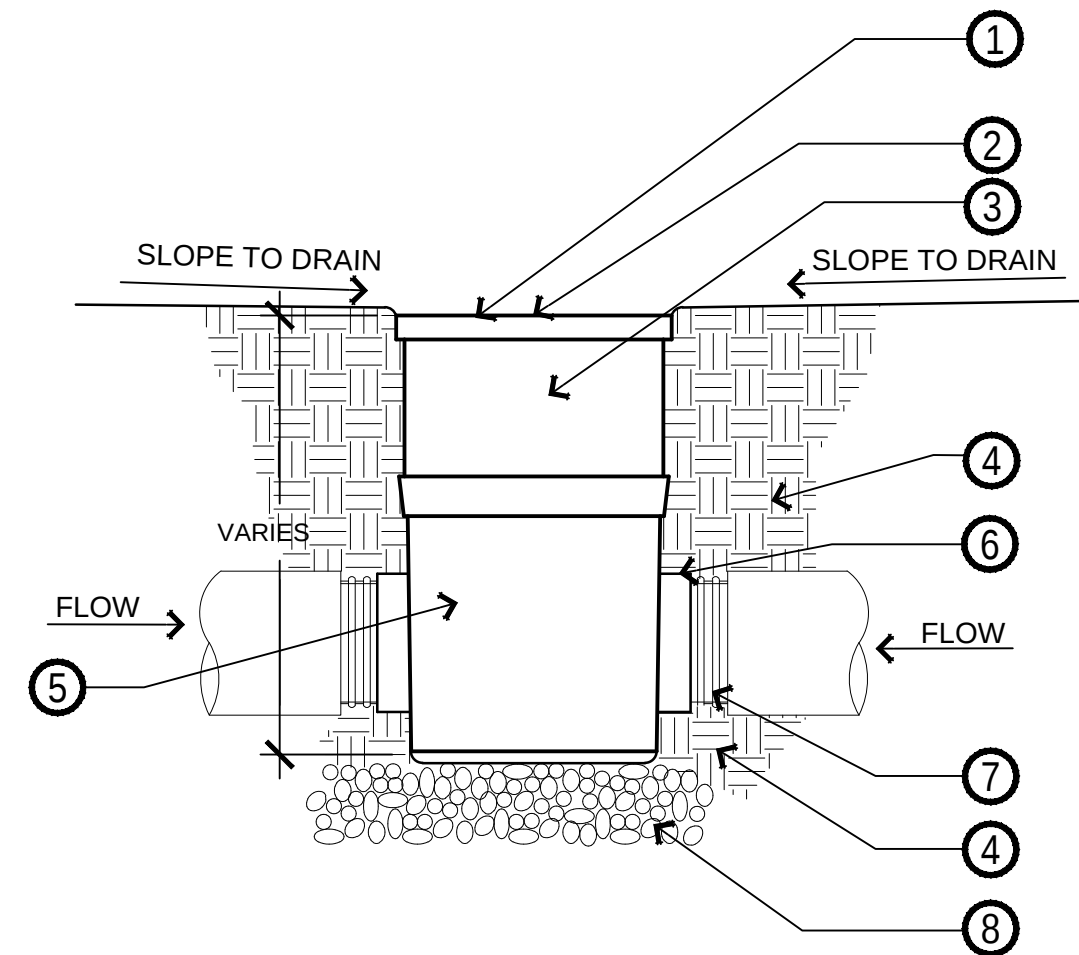

- ① TOP OF GRATE ELEVATION
- ② NDS CAST IRON GRATE
- ③ NDS 6-inch RISER WHERE REQUIRED
- ④ 90% COMPACTED SUBGRADE WHERE OCCURS
- ⑤ NDS 12-inch SQUARE CATCH BASIN
- ⑥ NDS UNIVERSAL LOCKING OUTLET
- ⑦ 4-inch EZFLOW DRAIN PIPE BY NDS
- ⑧ 4-inch DEPTH CRUSHED ROCK WHERE OCCURS

C 12-inch X 12-inch Catch Basin #1200, Grate #1213, NTS

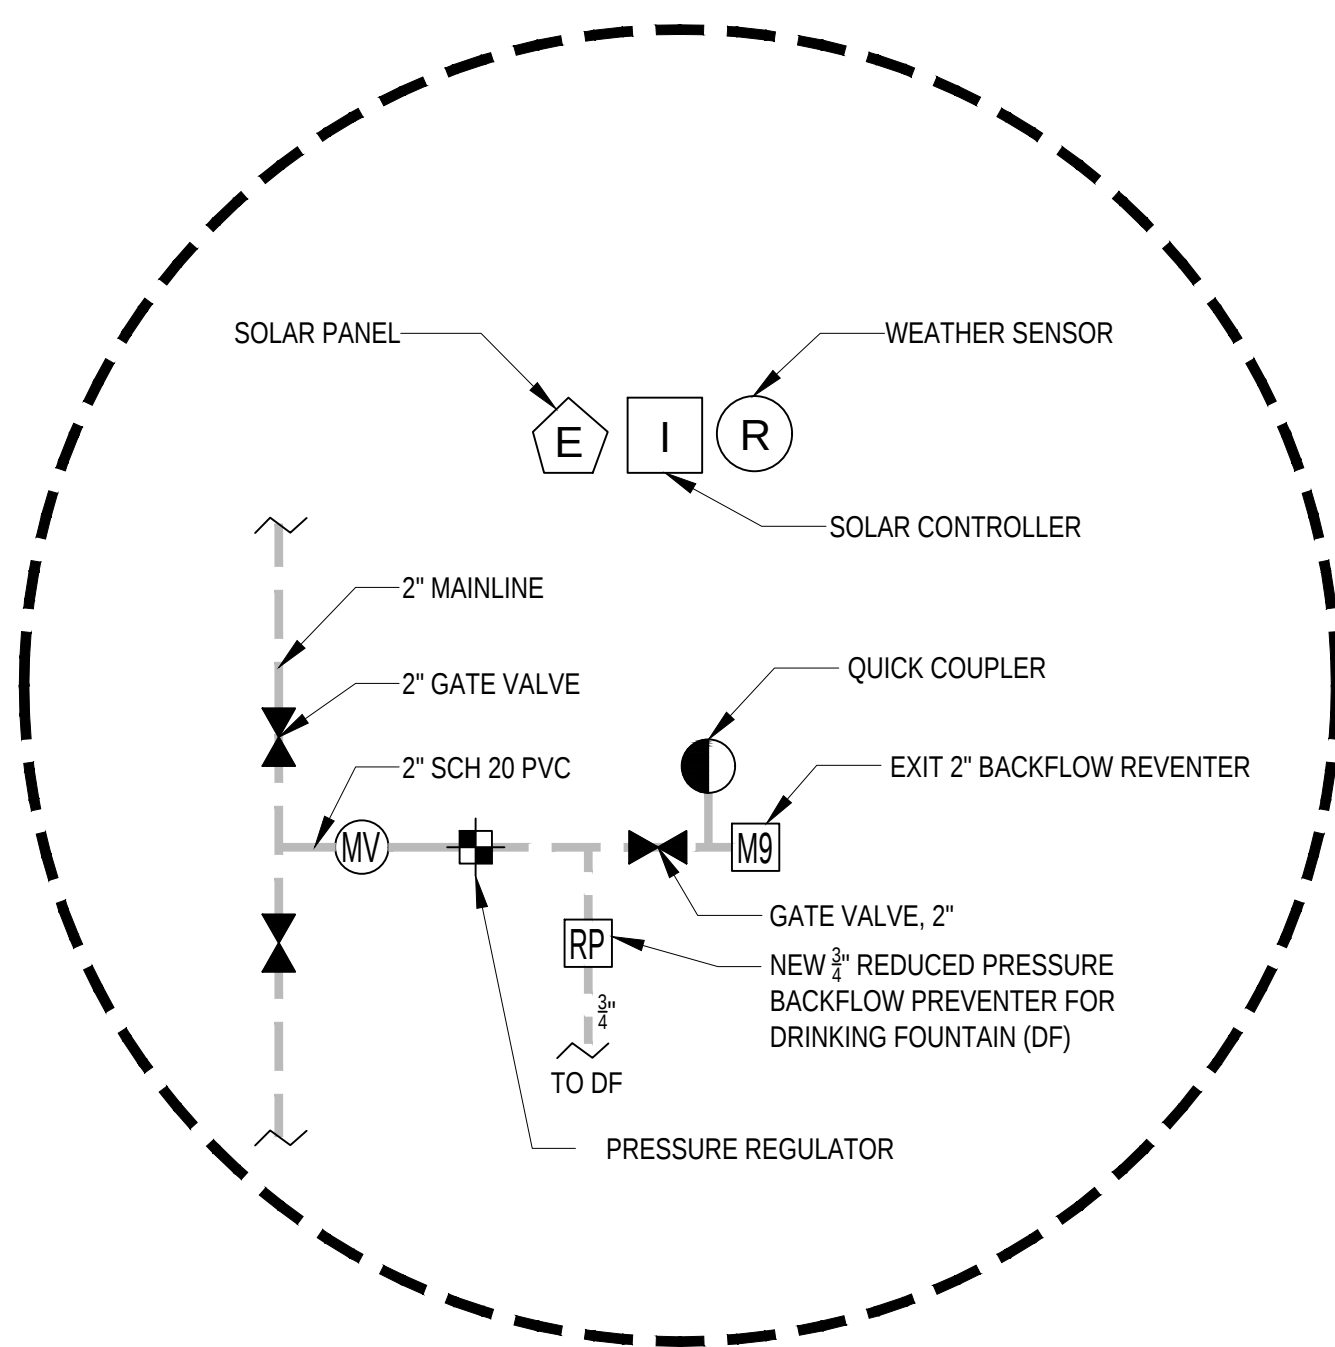


SLEEVING NOTE:
INSTALL SLEEVES FOR MAINLINES AND LATERALS AT ALL VEHICULAR CROSSINGS PRIOR TO INSTALLATION AND PLACEMENT. PROVIDE SEPARATE SLEEVES FOR CONTROL WIRES WHERE CROSSING PAVING. ALL SLEEVES CROSSING VEHICULAR PAVING SHALL HAVE A MINIMUM OF 36" COVER.

POINT OF CONNECTION NOTE:
MAKE POINT OF CONNECTION IMMEDIATELY DOWNSTREAM OF EXITING 2" BACK FLOW PREVENTER. REFER TO UTILITY PLANS FOR ADDITIONAL INFORMATION. EXTEND NEW TYPE 'K' COPPER PIPE (OR AS REQUIRED PER LOCAL CODE) TO LINE SIZED FATE VALVES AS SHOWN.

STATIC WATER PRESSURE: 100 PSI
SYSTEM DESIGNED PRESSURE: XX PSI
MAXIMUM IRRIGATION DEMAND: XX PSI

D POINT OF CONNECTION ENLARGEMENT NTS

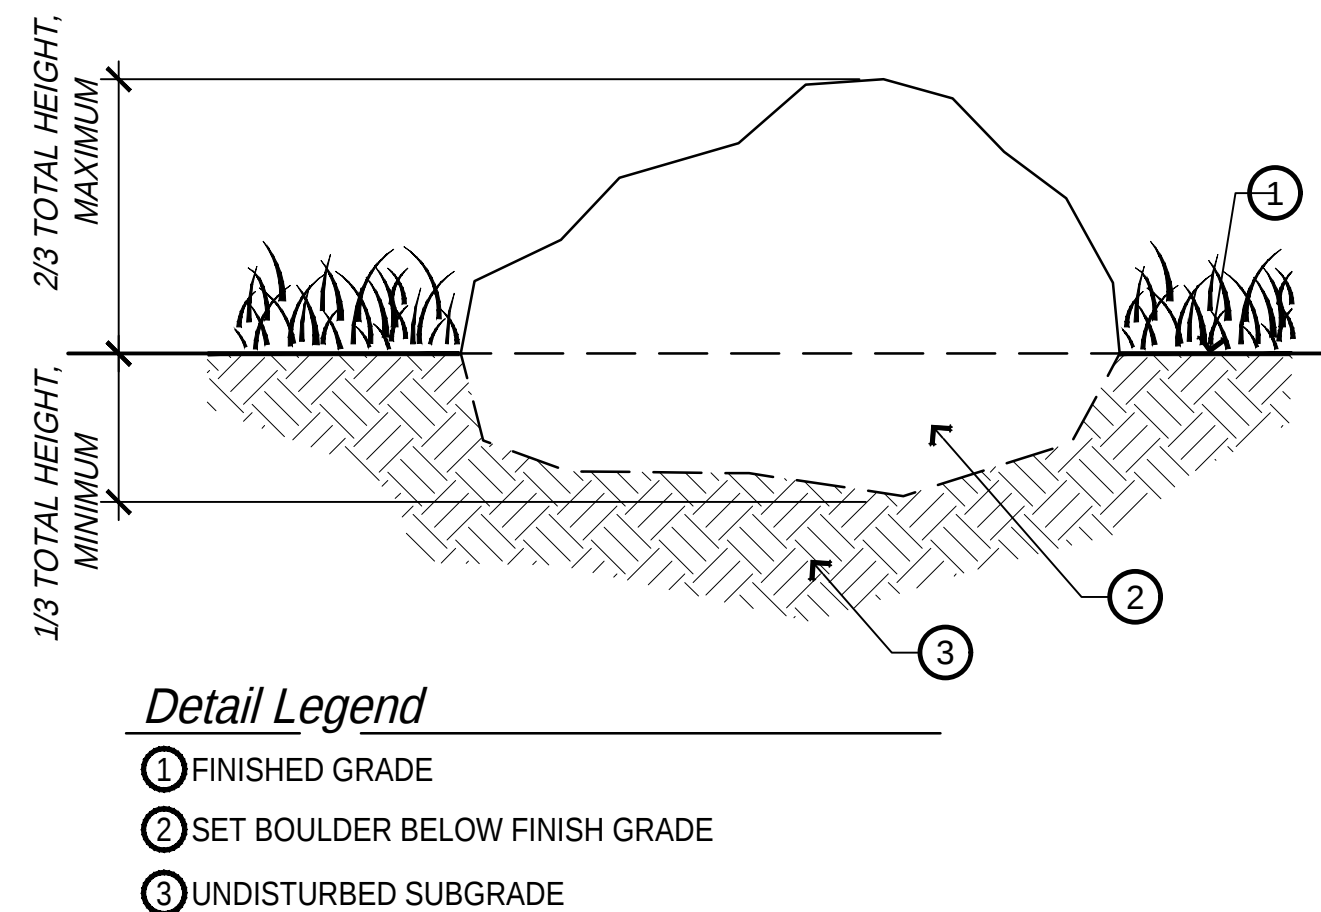

- Detail Legend
- ① FINISHED GRADE
 - ② SET BOULDER BELOW FINISH GRADE
 - ③ UNDISTURBED SUBGRADE


E LANDSCAPE BOULDER NTS

IRRIGATION / LANDSCAPE DETAILS


DESIGNED BY:		REVISIONS					CITY OF PASADENA - DEPARTMENT OF PUBLIC WORKS		
DRAWN BY:		MARK	DATE	DESCRIPTION	BY	CHKD.	APPROVED	PROJECT	SHEET 7 OF 8
CHECKED BY:								LIMITS	DWG. NO. #
				AS BUILT				SCALE 1"=40'	ACCOUNT NO. -

CORNERSTONE STUDIOS, INC.
951 E Santa Ana Blvd. Santa Ana, CA 92701
714. 973. 2200 Voice
714. 973. 0203 Fax
LANDSCAPE ARCHITECTURE • URBAN DESIGN • PLANNING • RESOURCE ANALYSIS




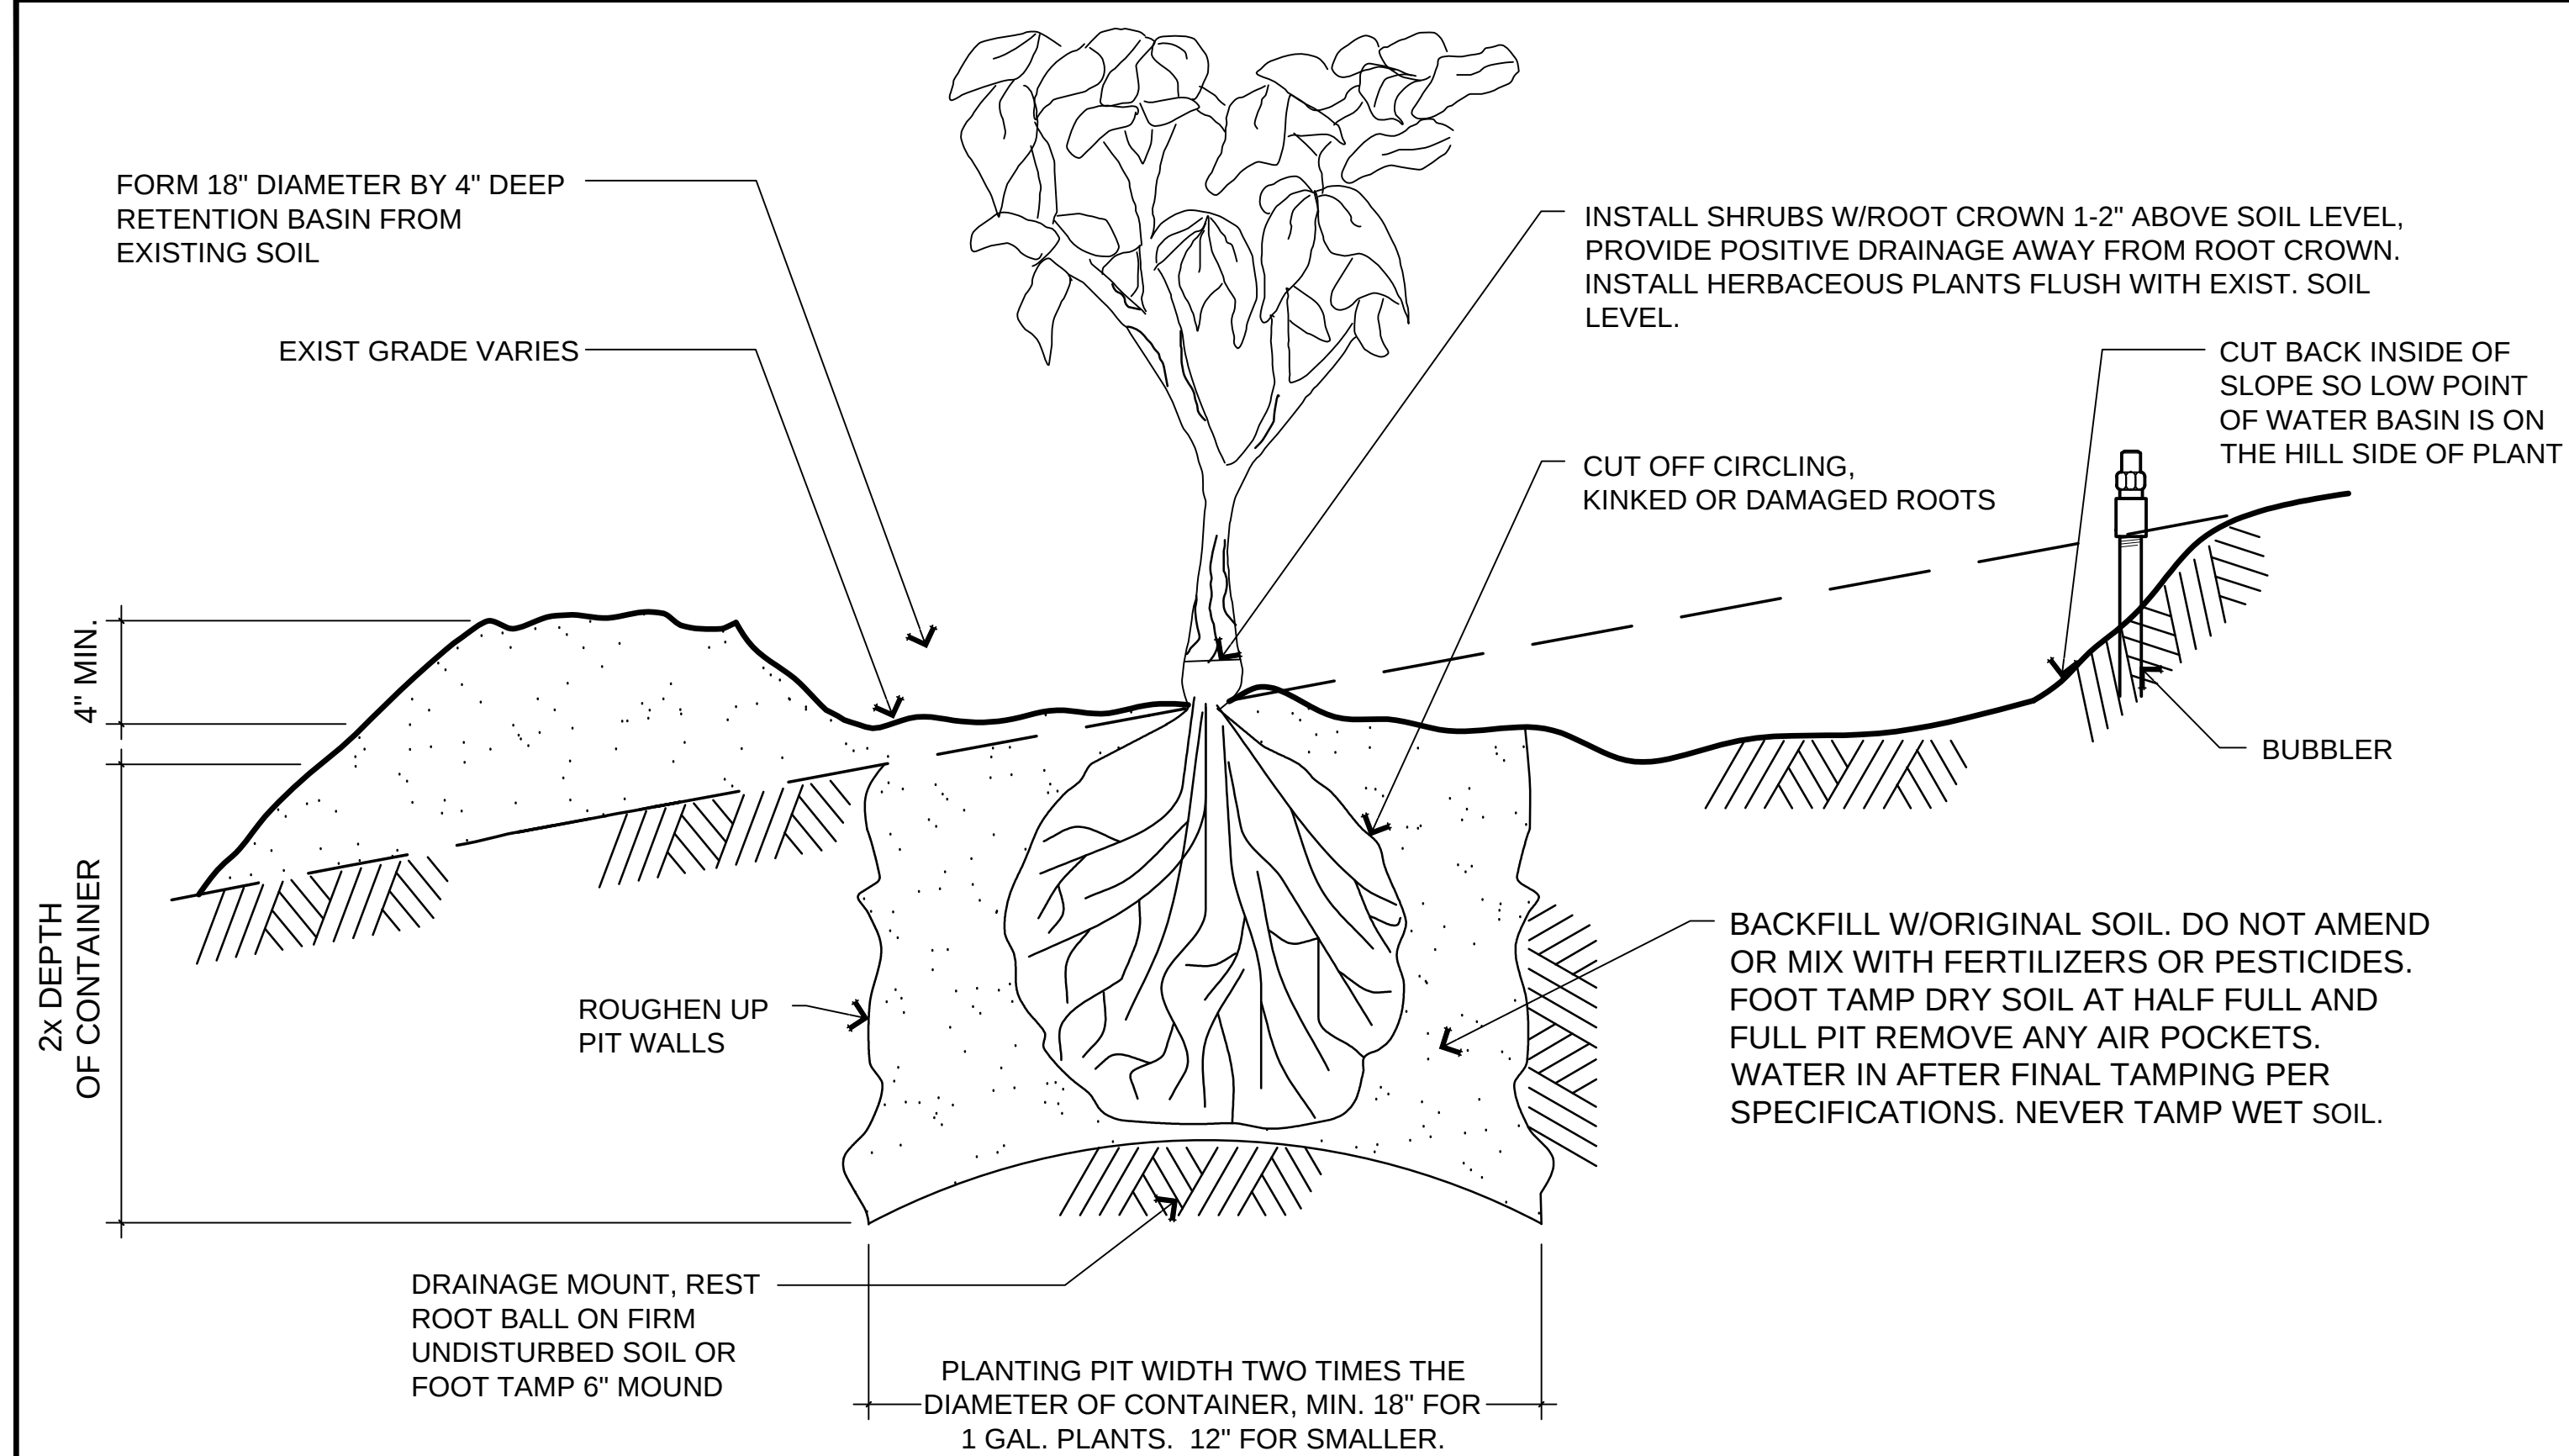


A *SHRUB/ HERBACEOUS SP. PLANTING DETAIL - SLOPES*
N.T.S.

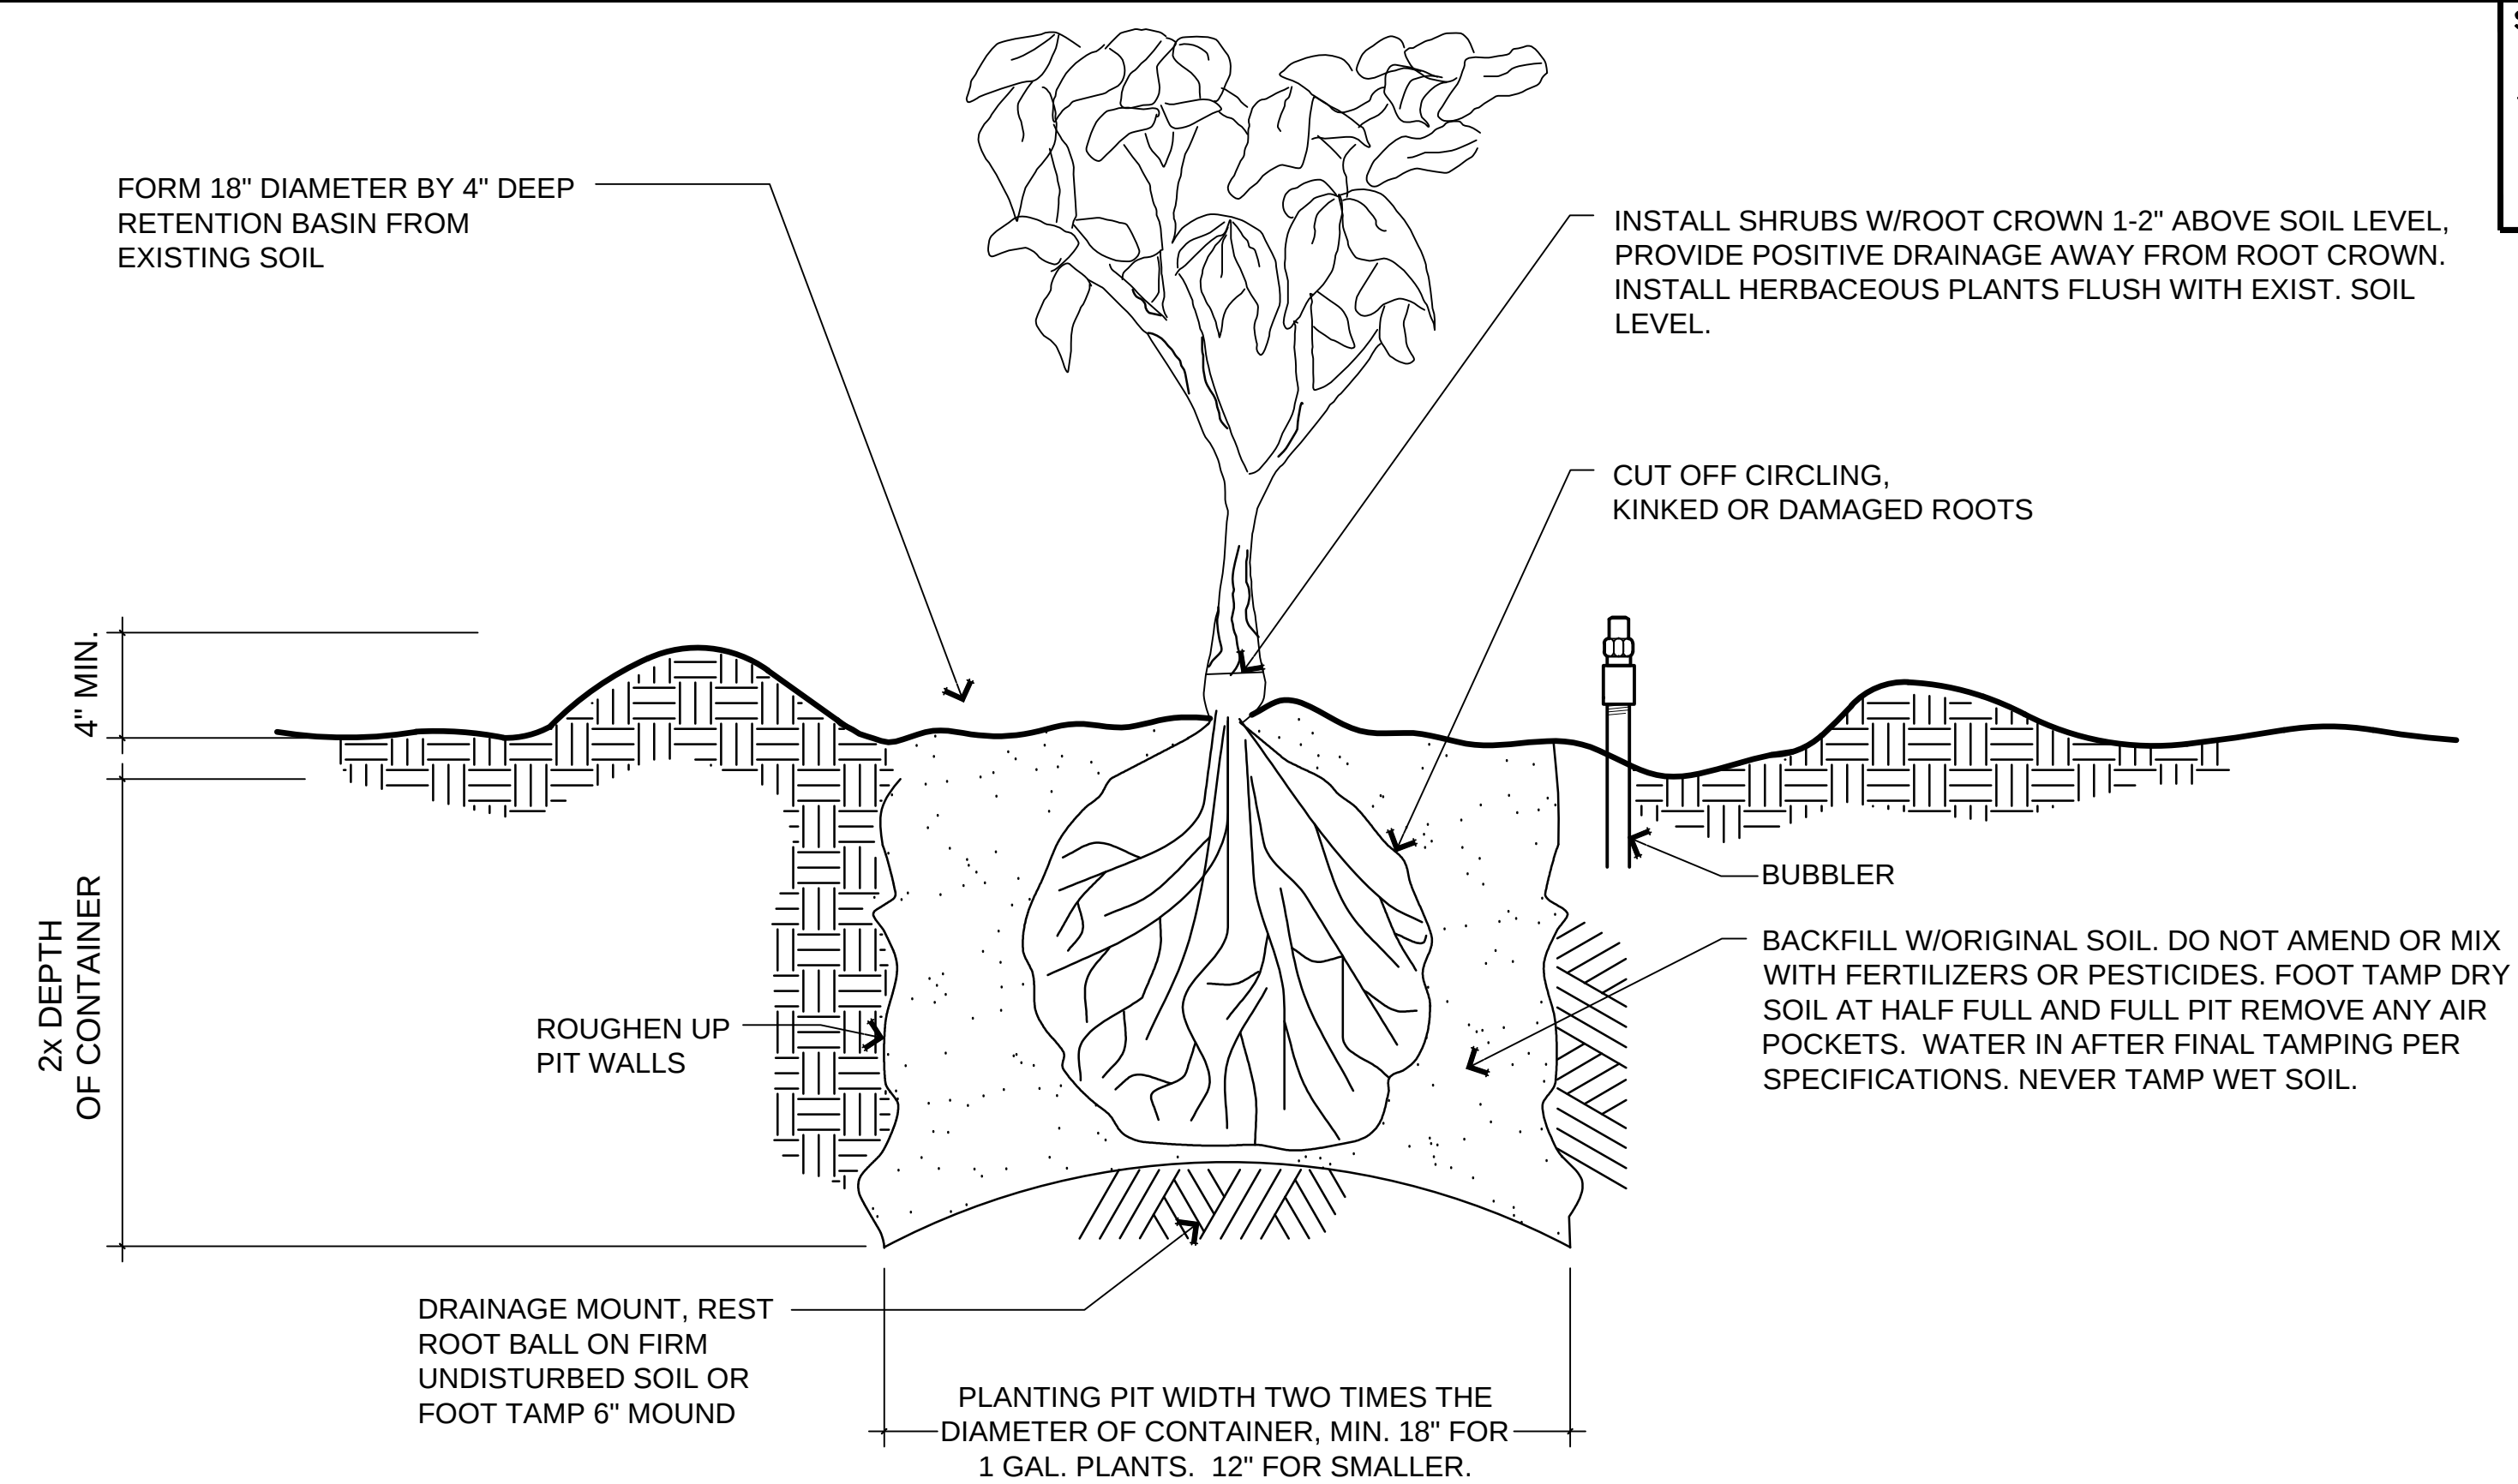


B *SHRUB/ HERBACEOUS SP. PLANTING DETAIL - LEVEL GROUND*
N.T.S.

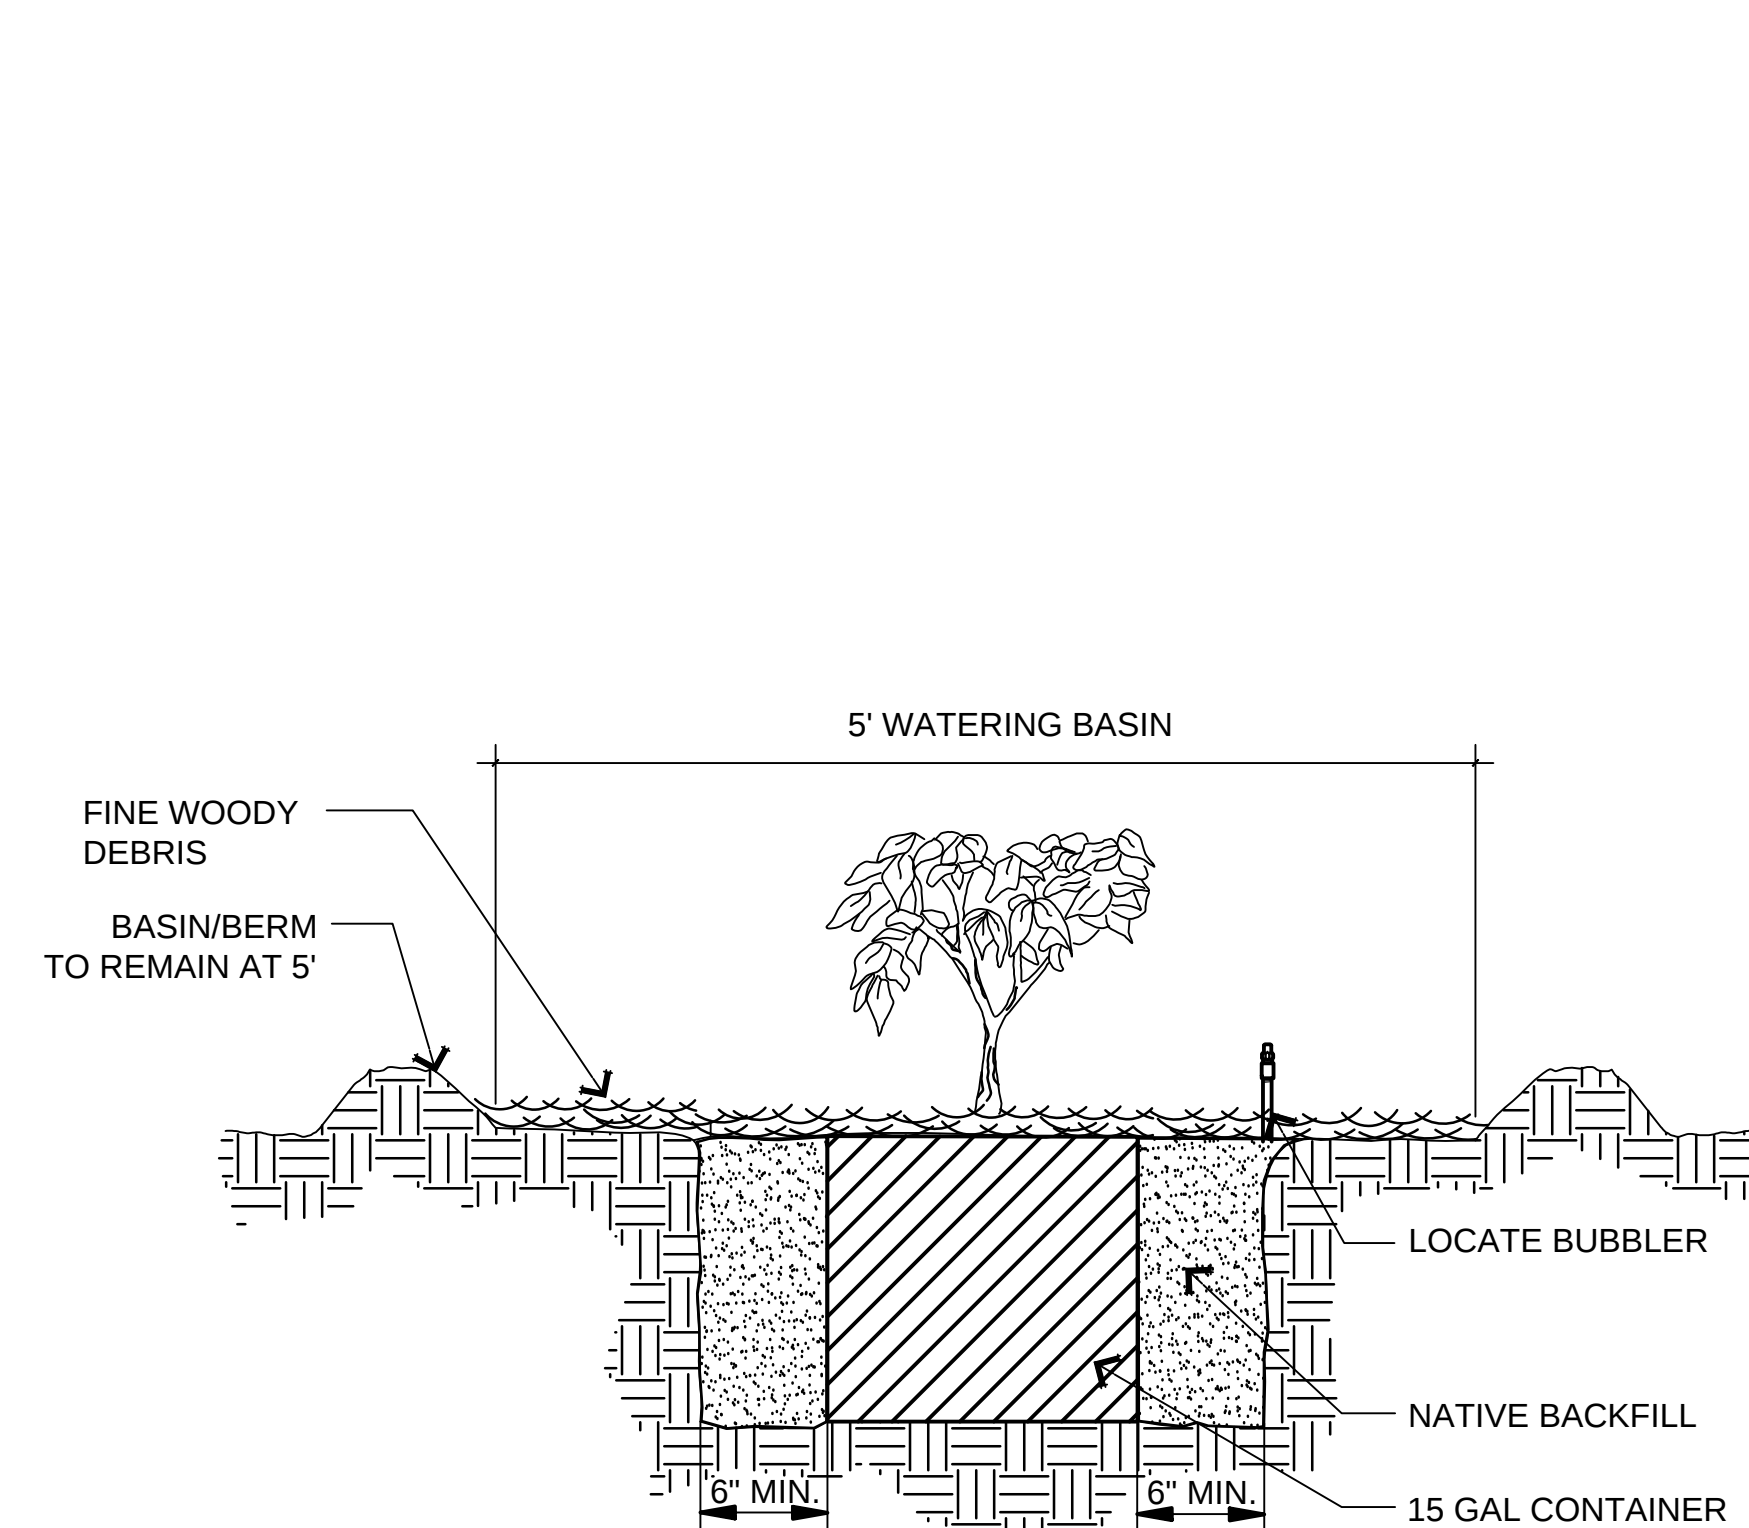

C *15G WESTERN SYCAMORE PLANTING*
N.T.S.

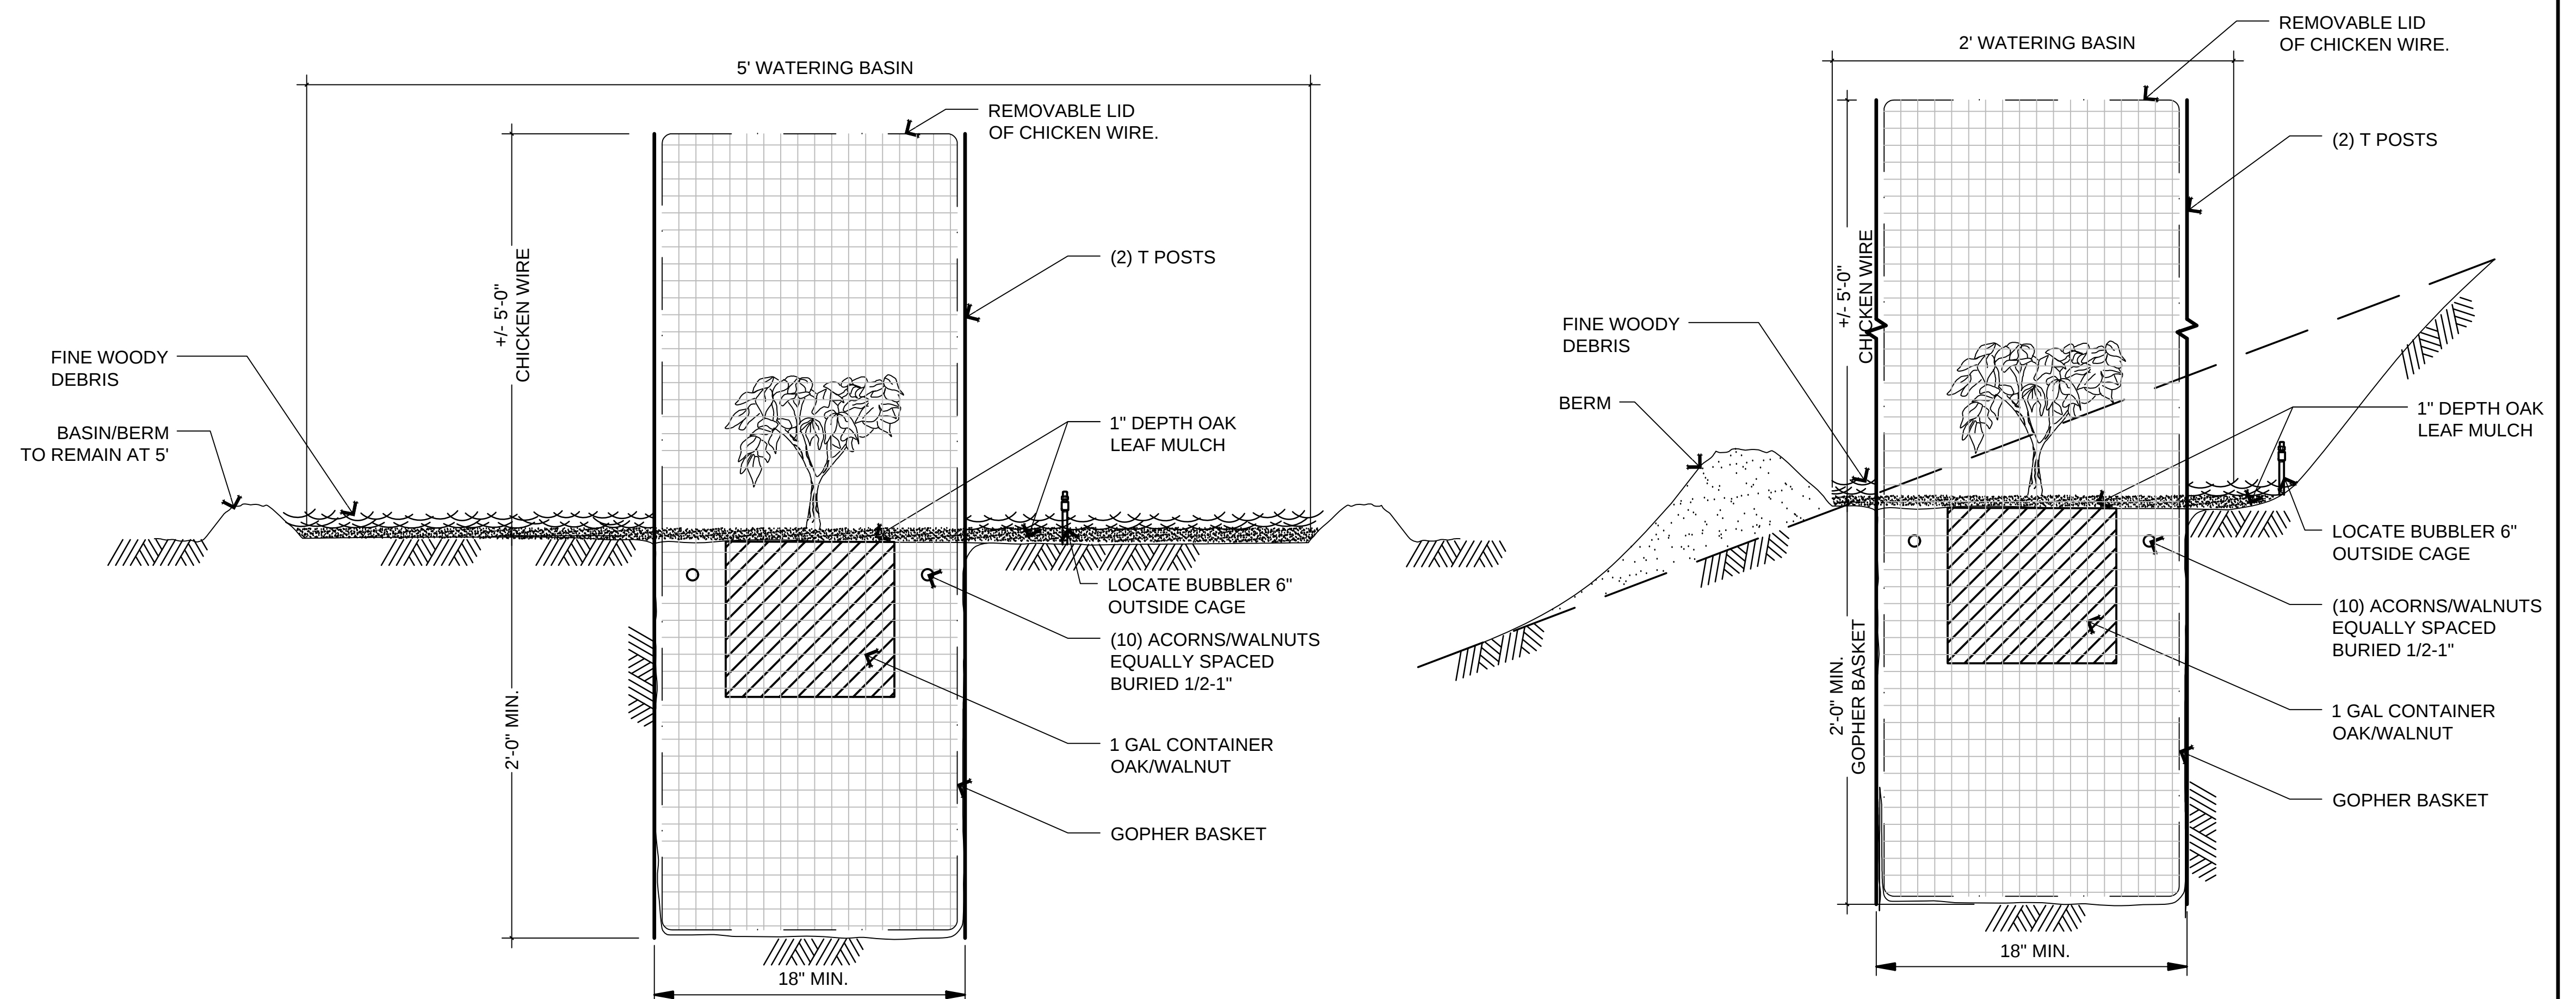

D *TYPE 1 OAK/WALNUT EXCLOSURE- LEVEL GROUND*
N.T.S.

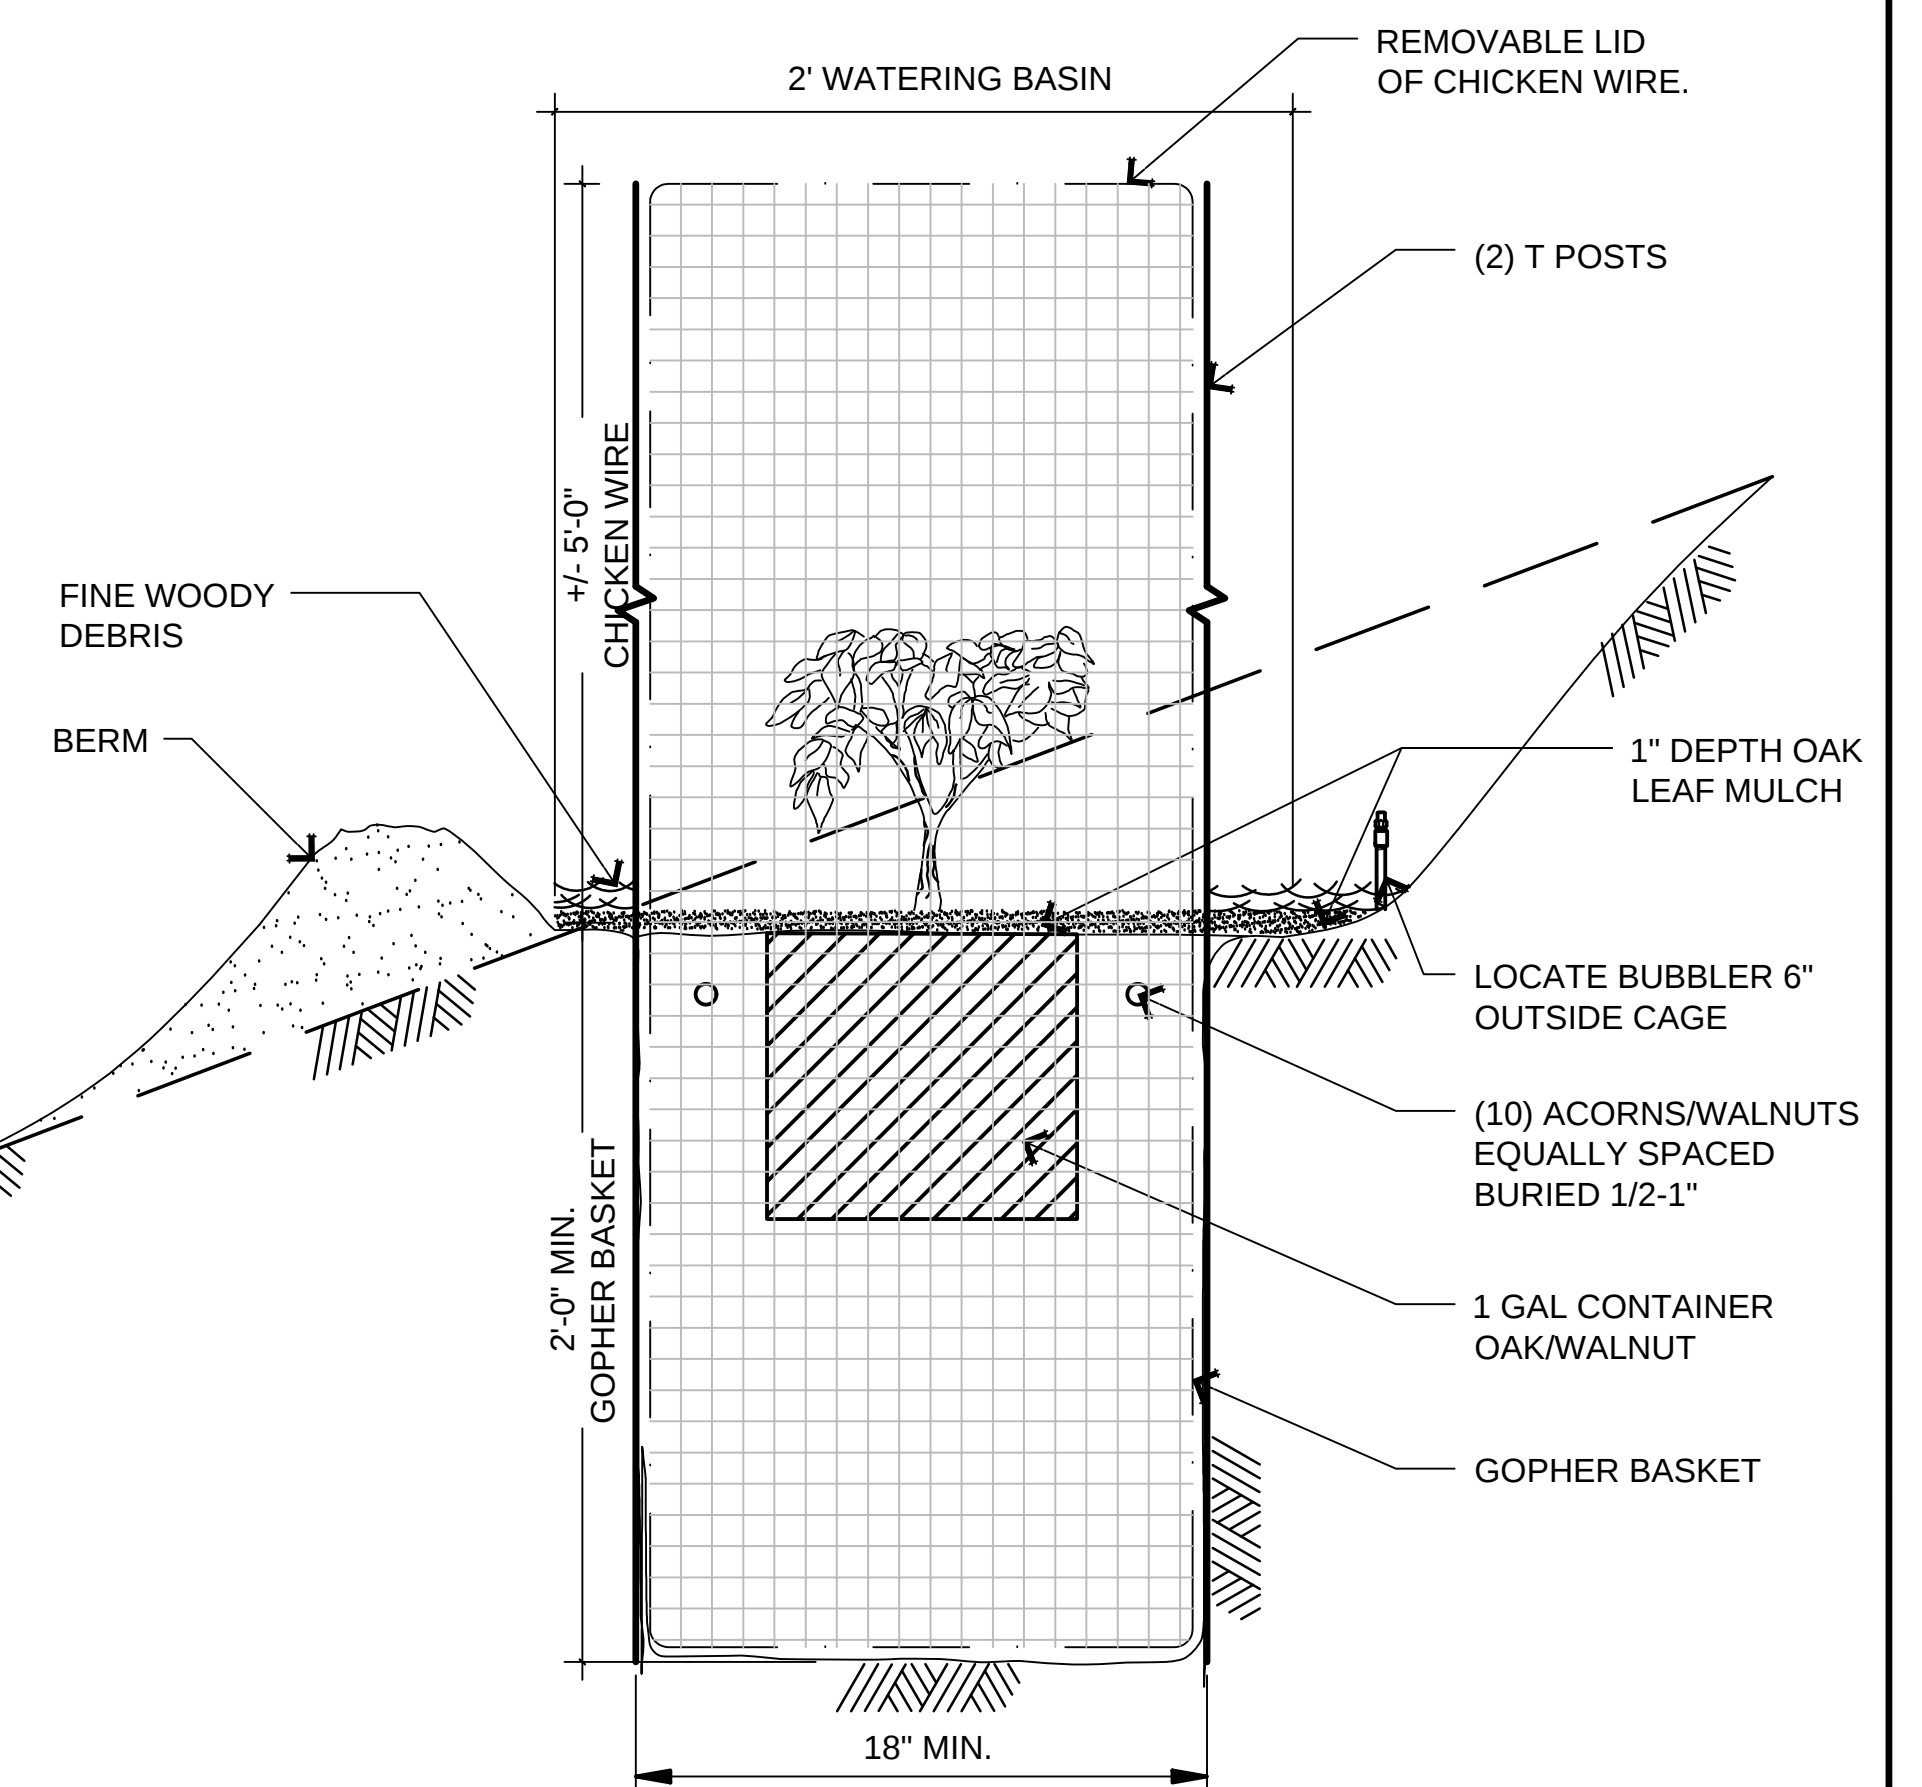

E *TYPE 2 OAK/WALNUT EXCLOSURE- SLOPES*
N.T.S.

PLANTING DETAILS

DESIGNED BY:	REVISIONS						CITY OF PASADENA - DEPARTMENT OF PUBLIC WORKS		
DRAWN BY:	MARK	DATE	DESCRIPTION	BY	CHKD.	APPROVED	PROJECT	LOWER ARROYO SECO / VAN DE KAMP BRIDGE HABITAT RESTORATION PROJECT	SHEET 8 OF 8
CHECKED BY:							LIMITS	-	DWG. NO. #
			AS BUILT				SCALE	AS NOTED	ACCOUNT NO. -

CORNERSTONE STUDIOS, INC.
951 E Santa Ana Blvd. 714. 973. 2200 Voice
Santa Ana, CA 92701 714. 973. 0203 Fax
LANDSCAPE ARCHITECTURE • URBAN DESIGN • PLANNING • RESOURCE ANALYSIS

